

**PLUMBING & SPRINKLER LEGEND**

- SOIL OR WASTE PIPING
- VENT PIPING
- COLD WATER PIPING
- HOT WATER PIPING
- SPRINKLER PIPING
- VALVE
- CHECK VALVE
- CLEAN OUT
- FLOOR DRAIN
- VENT TIRLU ROOF
- HOSE BIBB
- SILL COCK
- POST INDICATOR VALVE
- WATER CLOSET
- LAVATORY
- URINAL
- ELEC. WATER COOLER

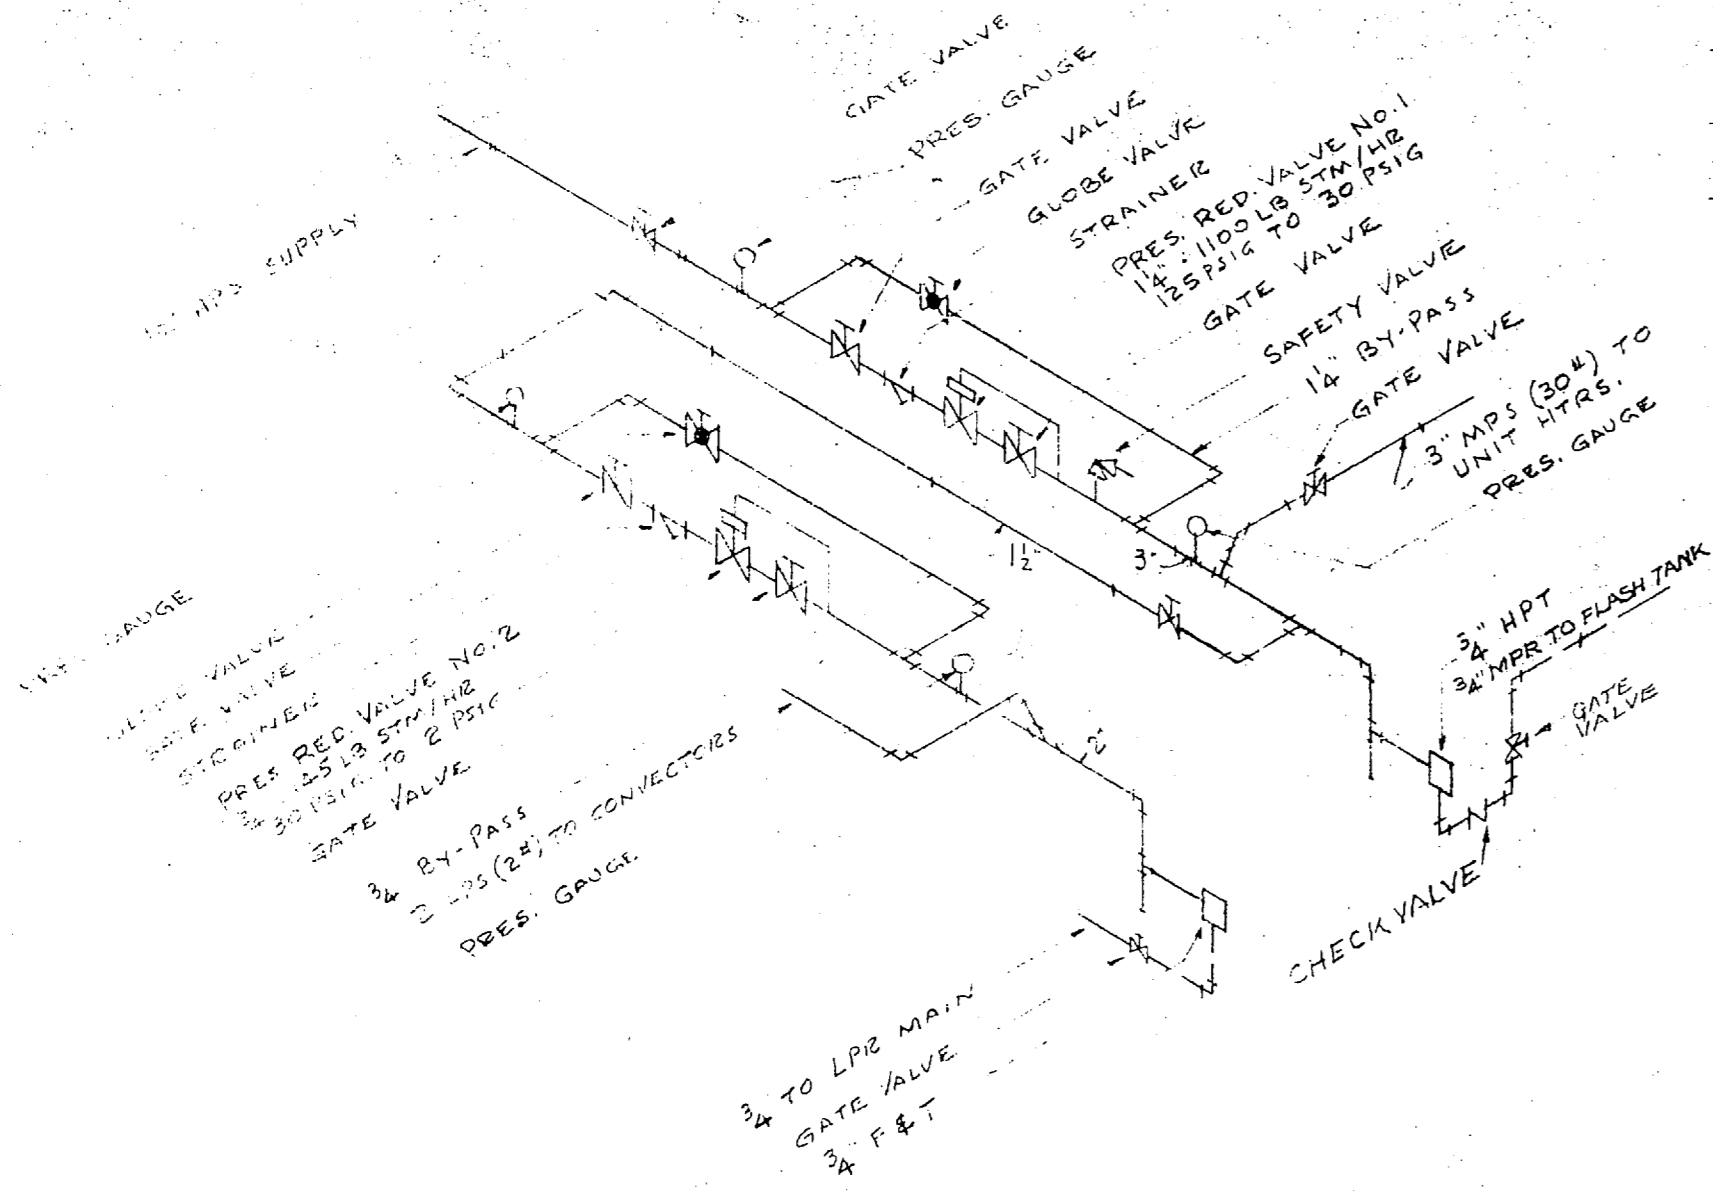


DIAGRAM OF PIPING AT PRV'S NOS. 1 & 2  
NO SCALE

SCHEDULE OF ROOF VENTILATORS					
NO.	CFM	S.P.	FAN DIA.	FAN RPM	MOTOR HP
1.	4950	1/2"	30"	455	1/2
2.	5520	1/2"	30"	530	3/4
3.	950	1/4"	9"	920	1/16

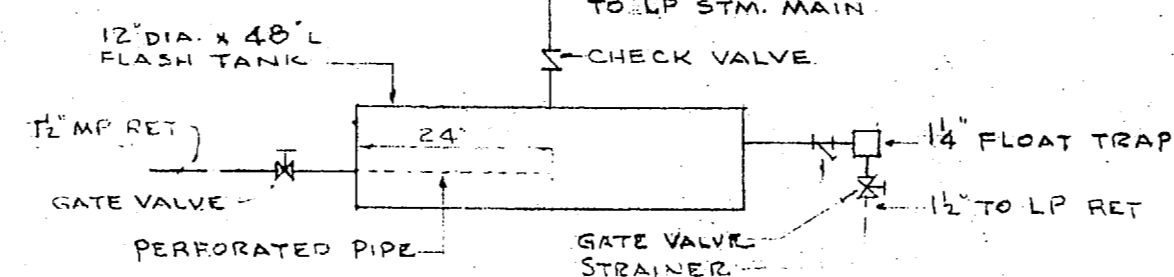


DIAGRAM OF PIPING AT FLASH TANK  
NO SCALE



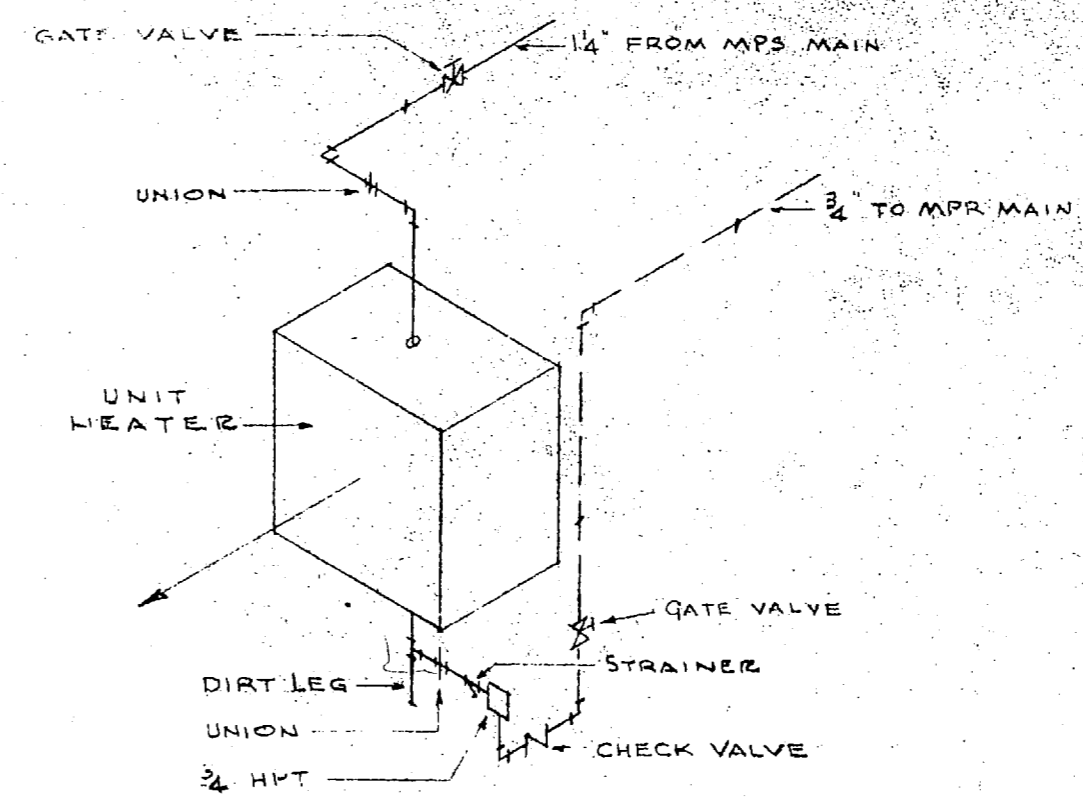



DIAGRAM OF PIPING AT UNIT HEATERS  
NO SCALE

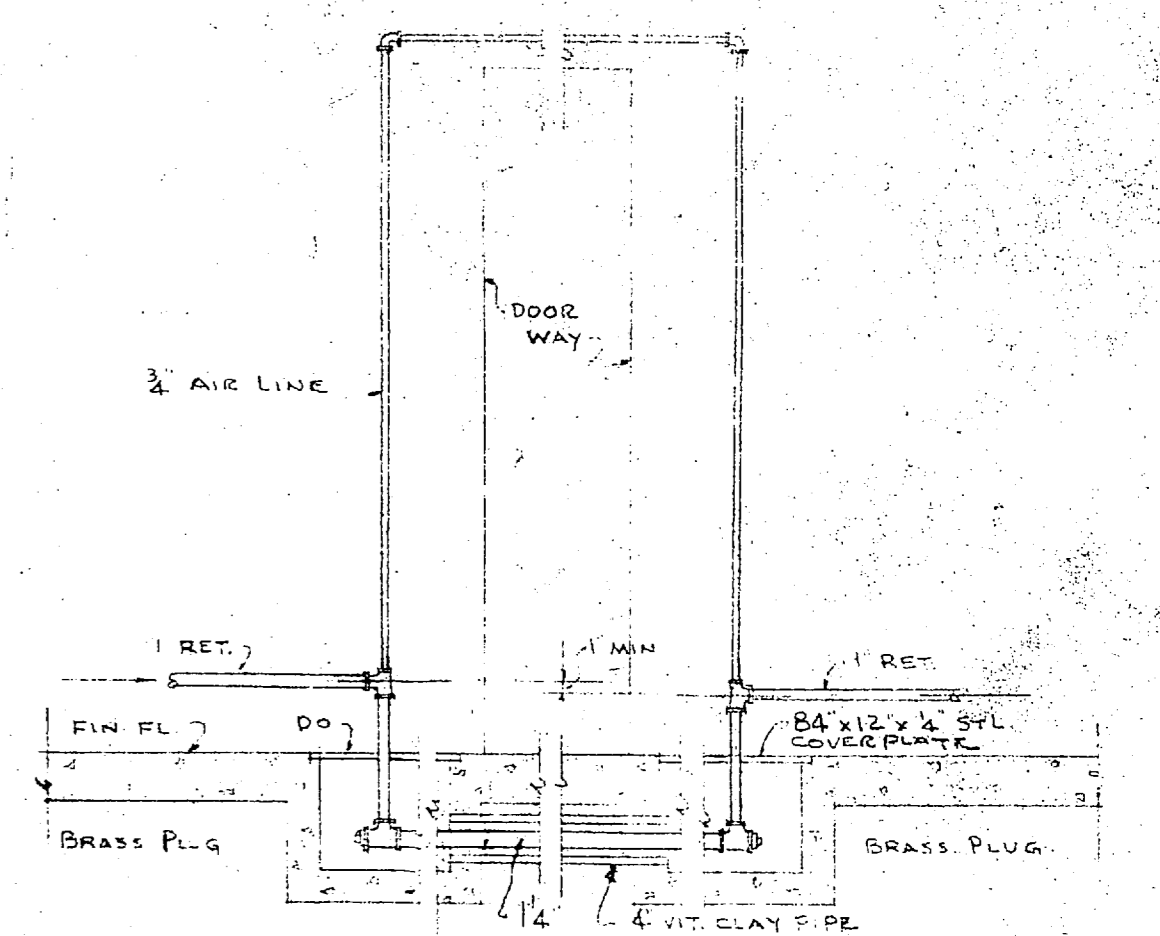

DETAIL OF AIR LOOP AROUND DOORWAY  
NO SCALE

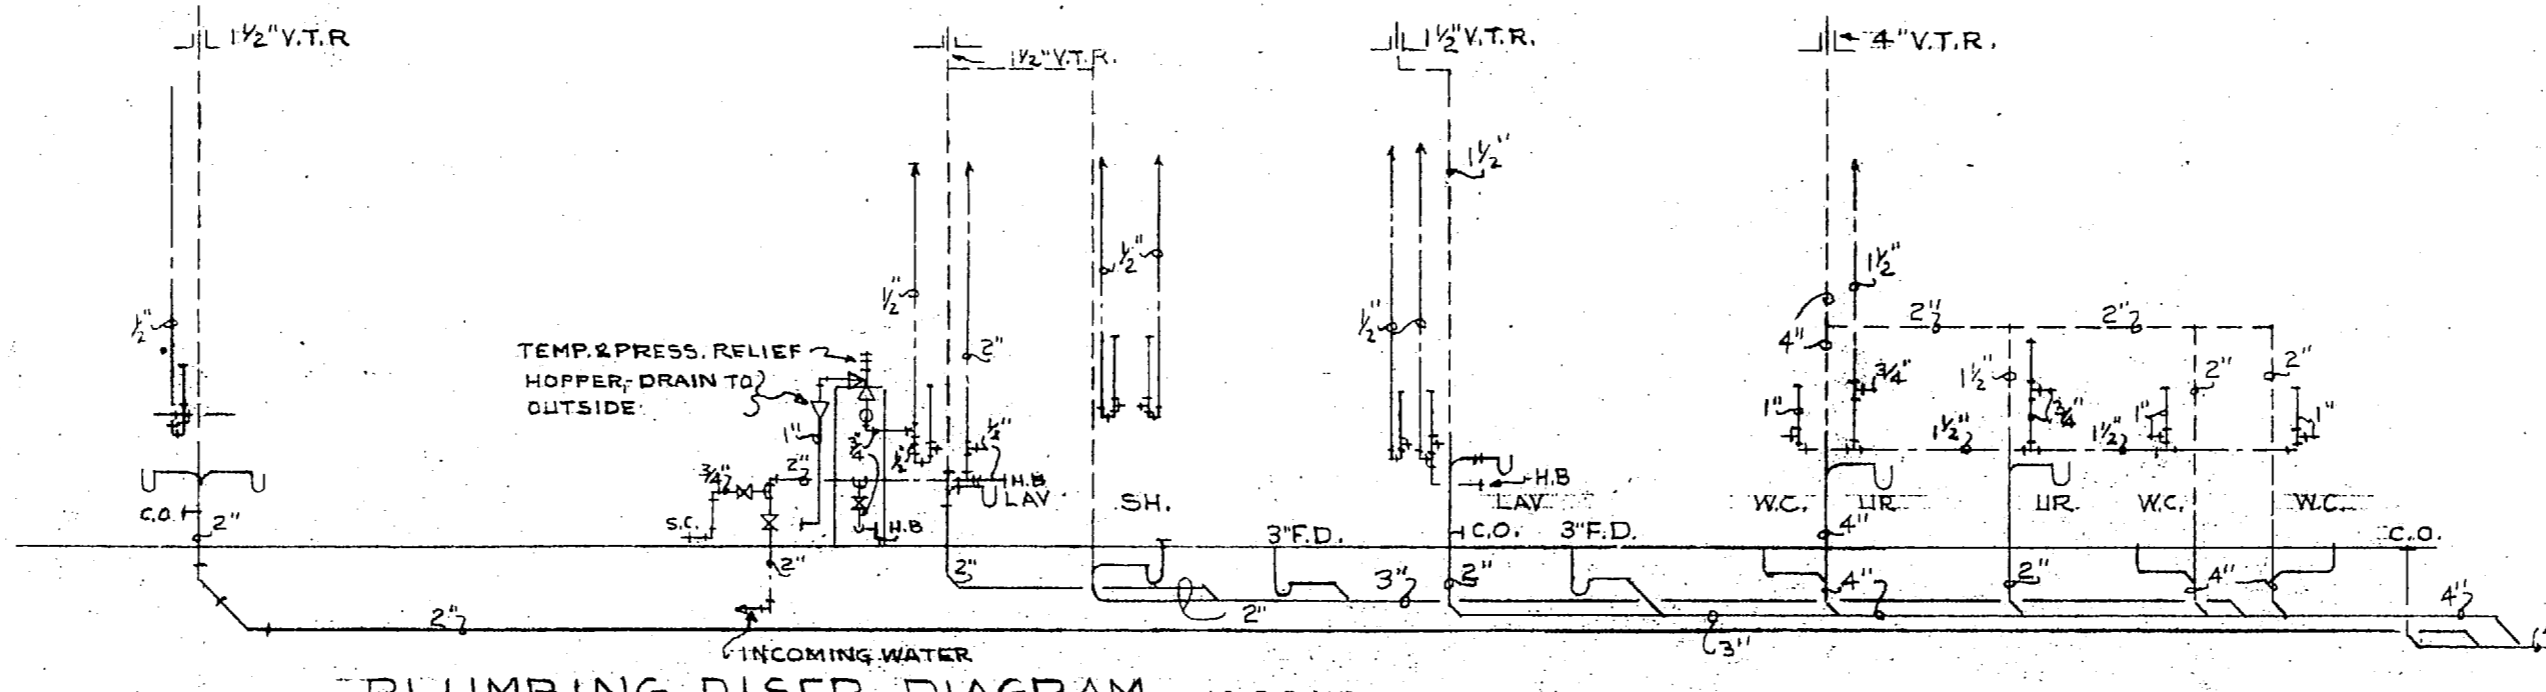


PLUMBING RISER DIAGRAM  
NO SCALE

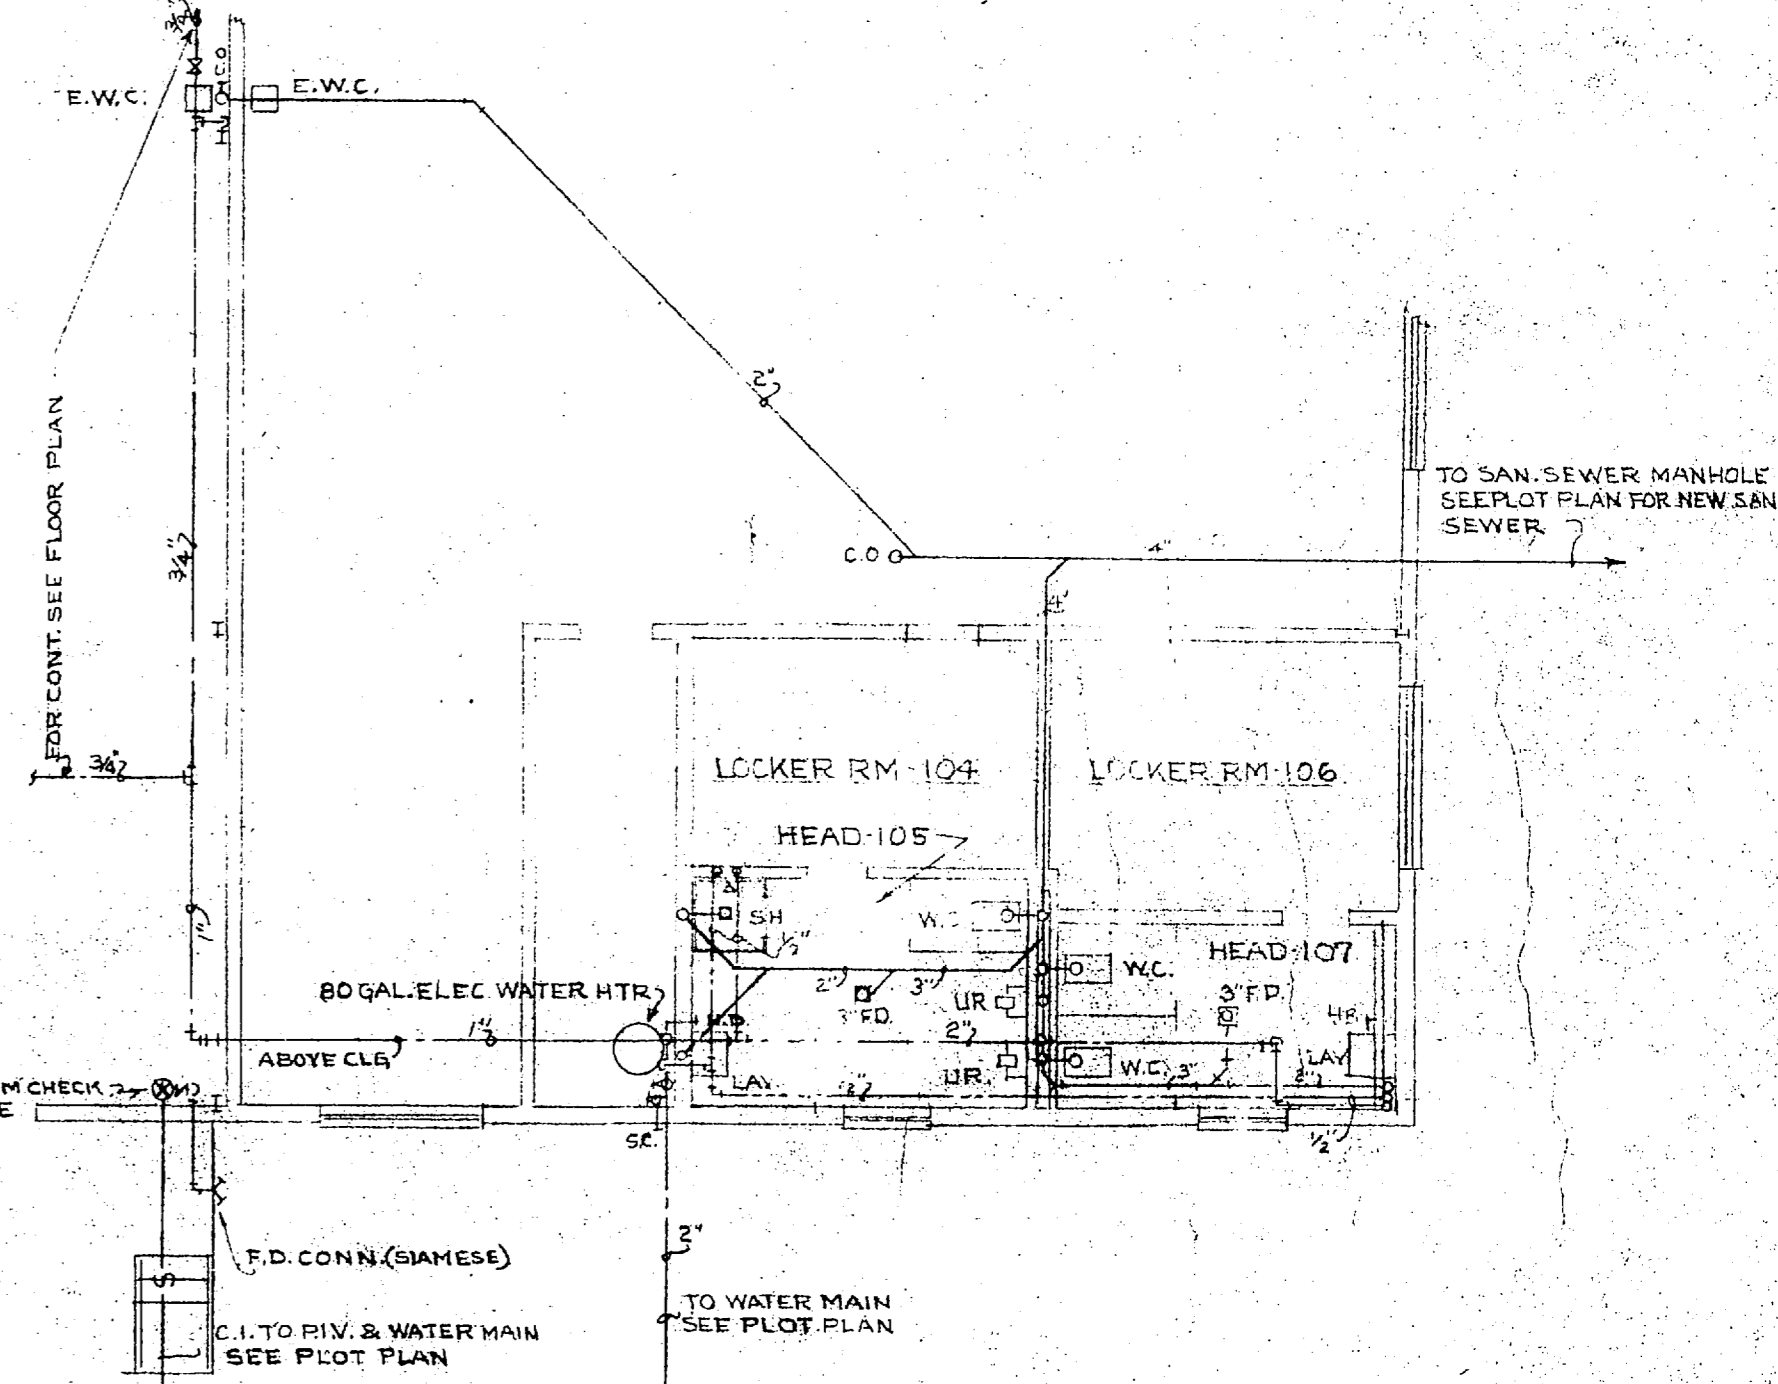


PART PLAN PLUMBING SCALE: 1/8" = 1'-0"

- HEATING LEGEND**
- HIGH PRESSURE STEAM (25 PSIG)
  - HIGH PRESSURE RETURN
  - MEDIUM PRESSURE STEAM (30 PSIG)
  - MEDIUM PRESSURE RETURN
  - LOW PRESSURE STEAM (2 PSIG)
  - LOW PRESSURE RETURN
  - PUMP DISCHARGE
  - GATE VALVE
  - GLOBE VALVE
  - CONTROL VALVE
  - REDUCING VALVE
  - CHECK VALVE
  - THERMOSTAT
  - HIGH PRESSURE TRAP
  - FLOAT & THERMOSTATIC TRAP
  - THERMOSTATIC TRAP
  - REGISTER

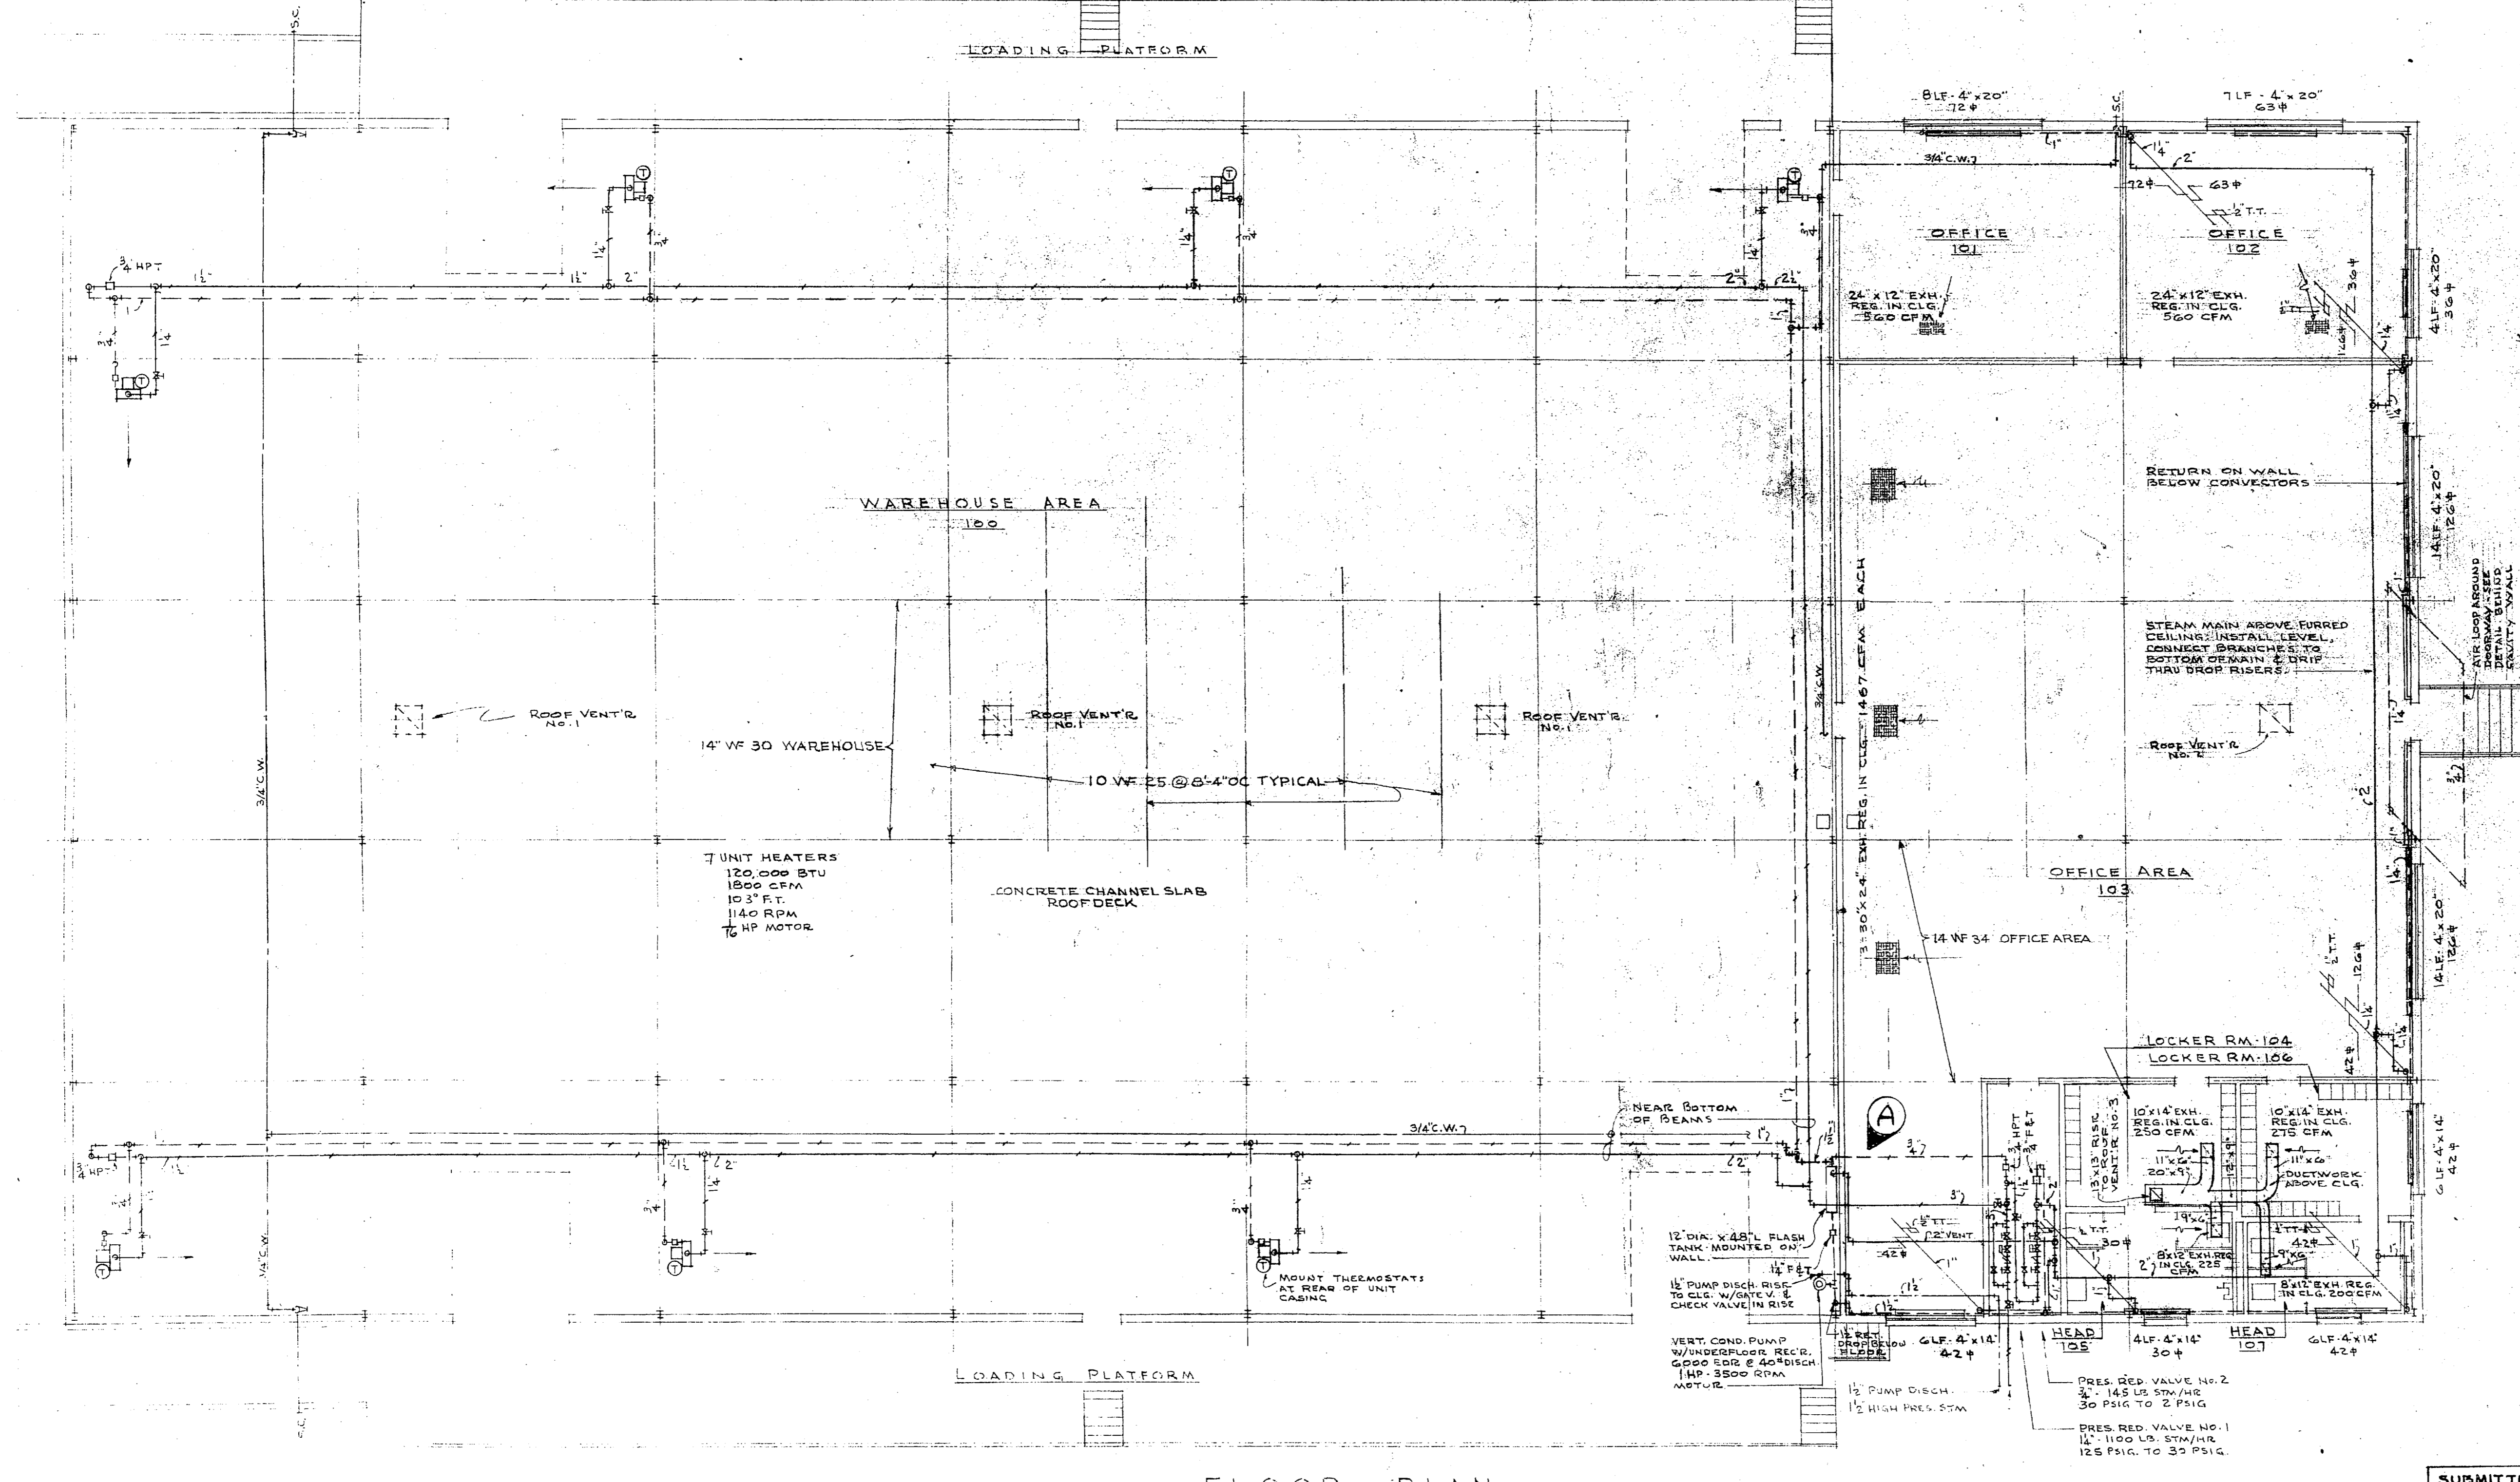

FLOOR PLAN  
SCALE: 1/8" = 1'-0"

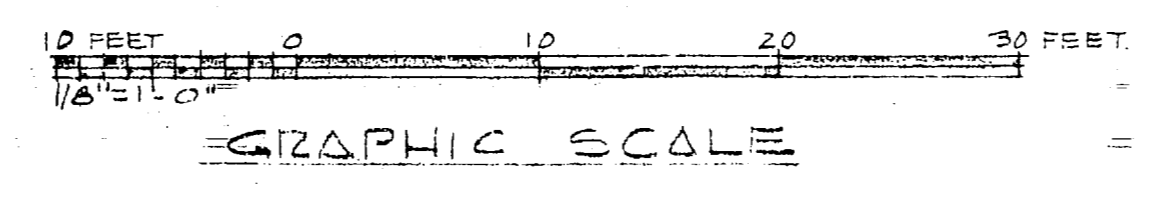

**REVISION DRAWING**  
SHEET 2 OF 2  
REVISED IN O.C. 9/23/62 DATED 11/7/62 AS 130

AS 130

SUBMITTED BY J.N. PEASE & COMPANY  
*J.N. Pease*  
DATE: MAR 14 1963  
SIGNATURE AND TITLE

REVISIONS

SYMBOL	REVISIONS	DATE	APPROVAL
REVISED (AS BUILT)		11/7/62	

D.F.W. DRAWING NO. 46759  
DEPARTMENT OF THE NAVY  
DISTRICT PUBLIC WORKS OFFICE  
ENGINEERS & ARCHITECTS  
J. N. PEASE & COMPANY  
CHARLOTTE, NORTH CAROLINA  
NEW BRUNSWICK, NEW JERSEY  
JAC. G. SONVILLE, NC

DESIGNED BY: J.N. PEASE  
DRAWN BY: J.N. PEASE  
CHECKED BY: J.N. PEASE  
PROJECT WORKSHEET NO. 1  
DWG. NO. 1

APPROVED BY: J.N. PEASE  
DATE: MAR 14 1963

OFFICE IN CHARGE: DISTRICT PUBLIC WORKS OFFICE  
DATE: MAR 14 1963

APPROVED BY: J.N. PEASE  
DATE: MAR 14 1963


APPROVED BY: J.N. PEASE  
DATE: MAR 14 1963

APPROVED BY: J.N. PEASE  
DATE: MAR 14 1963







AS-504

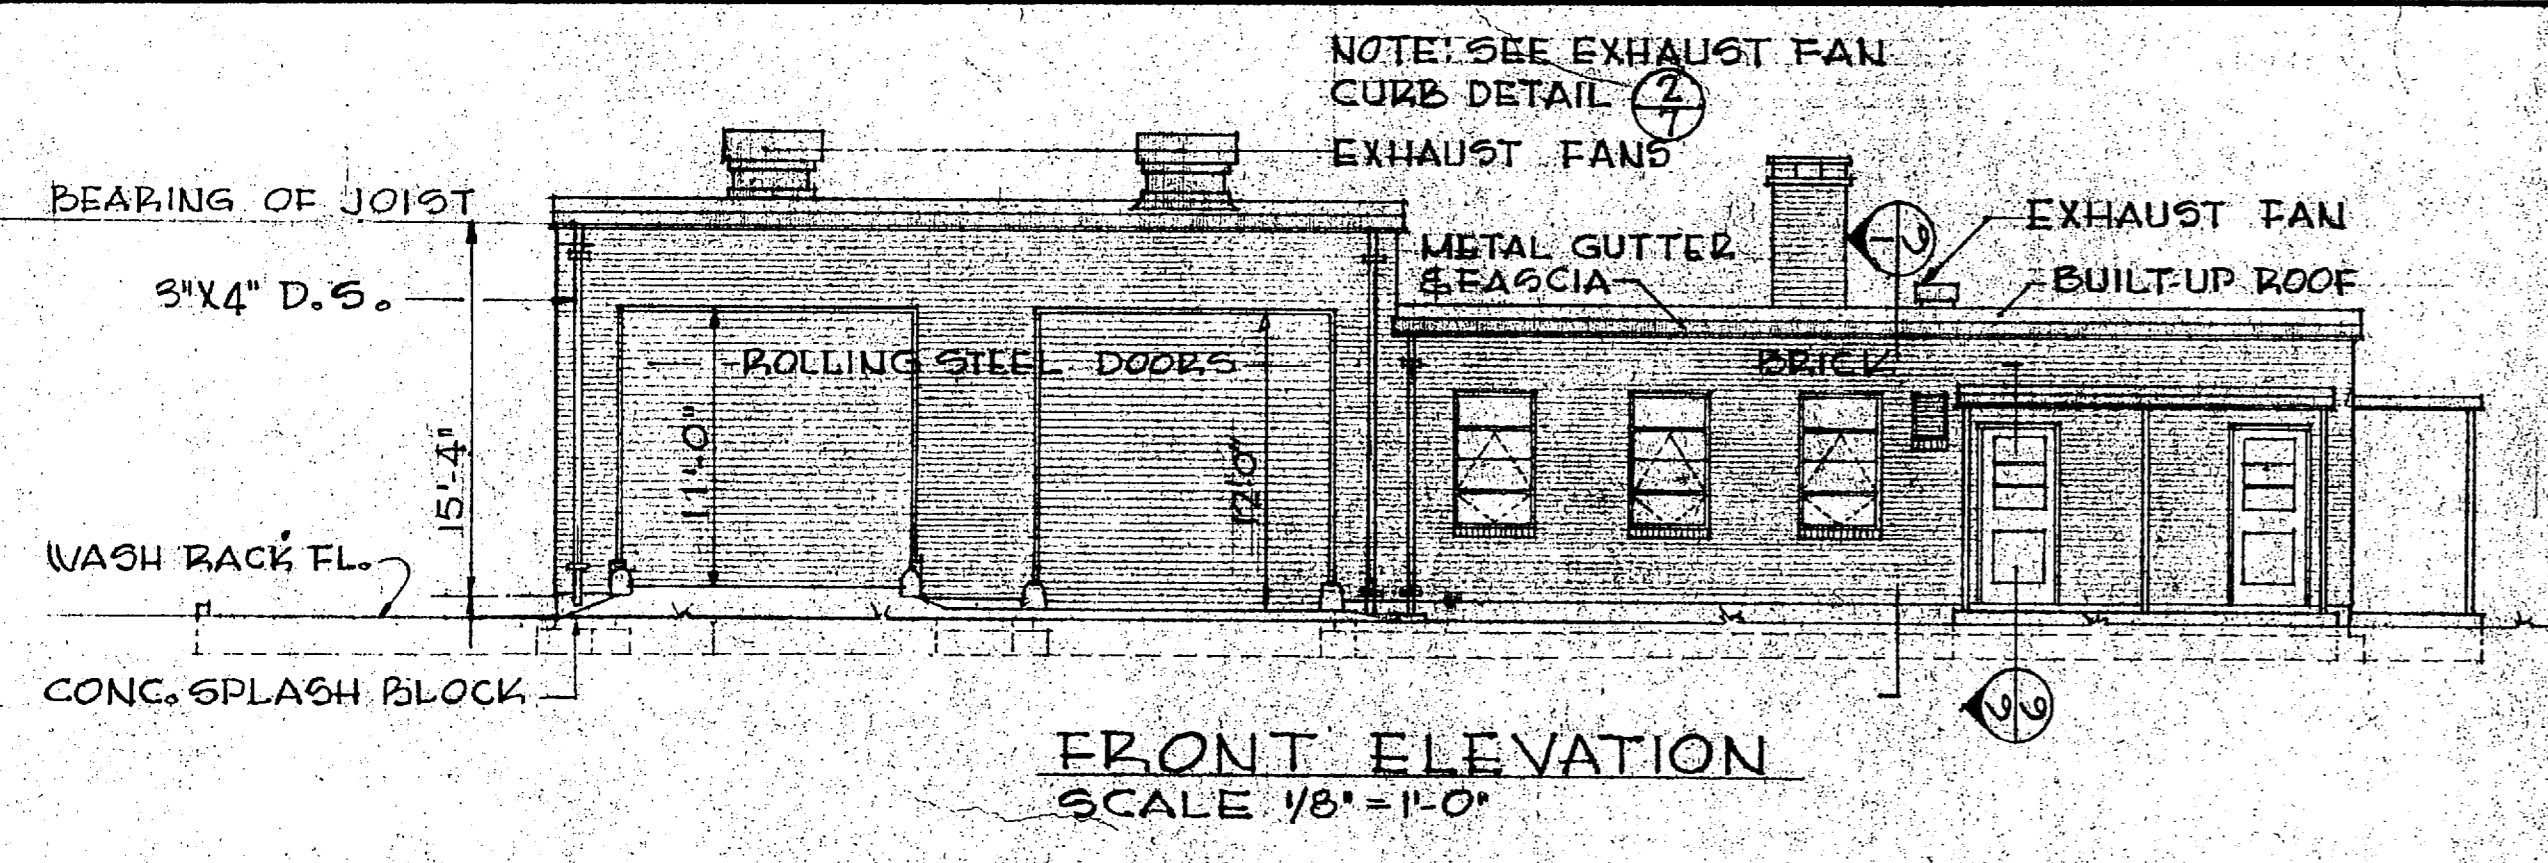

FRONT ELEVATION  
SCALE 1/8" = 1'-0"

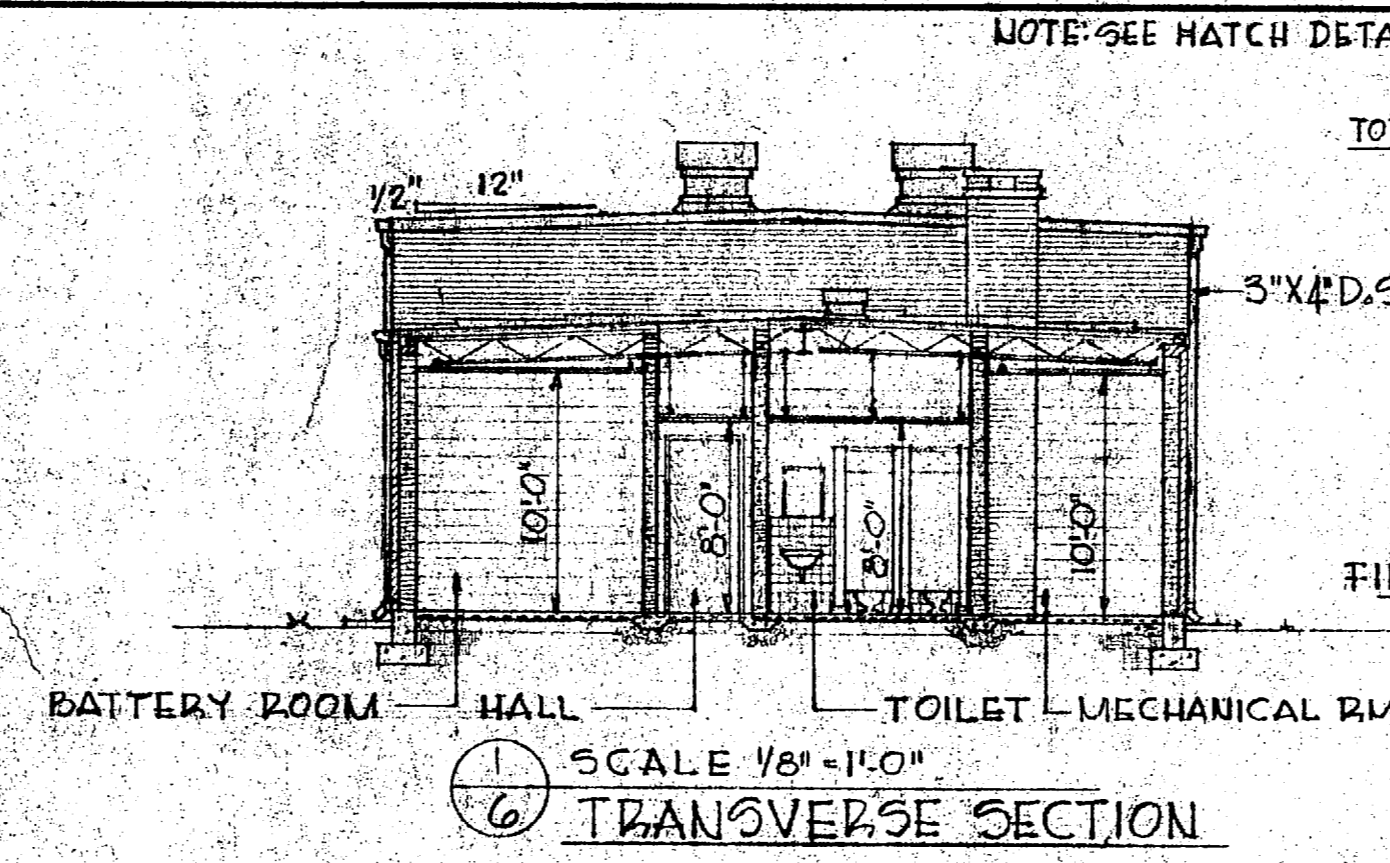


TRANSVERSE SECTION  
SCALE 1/8" = 1'-0"

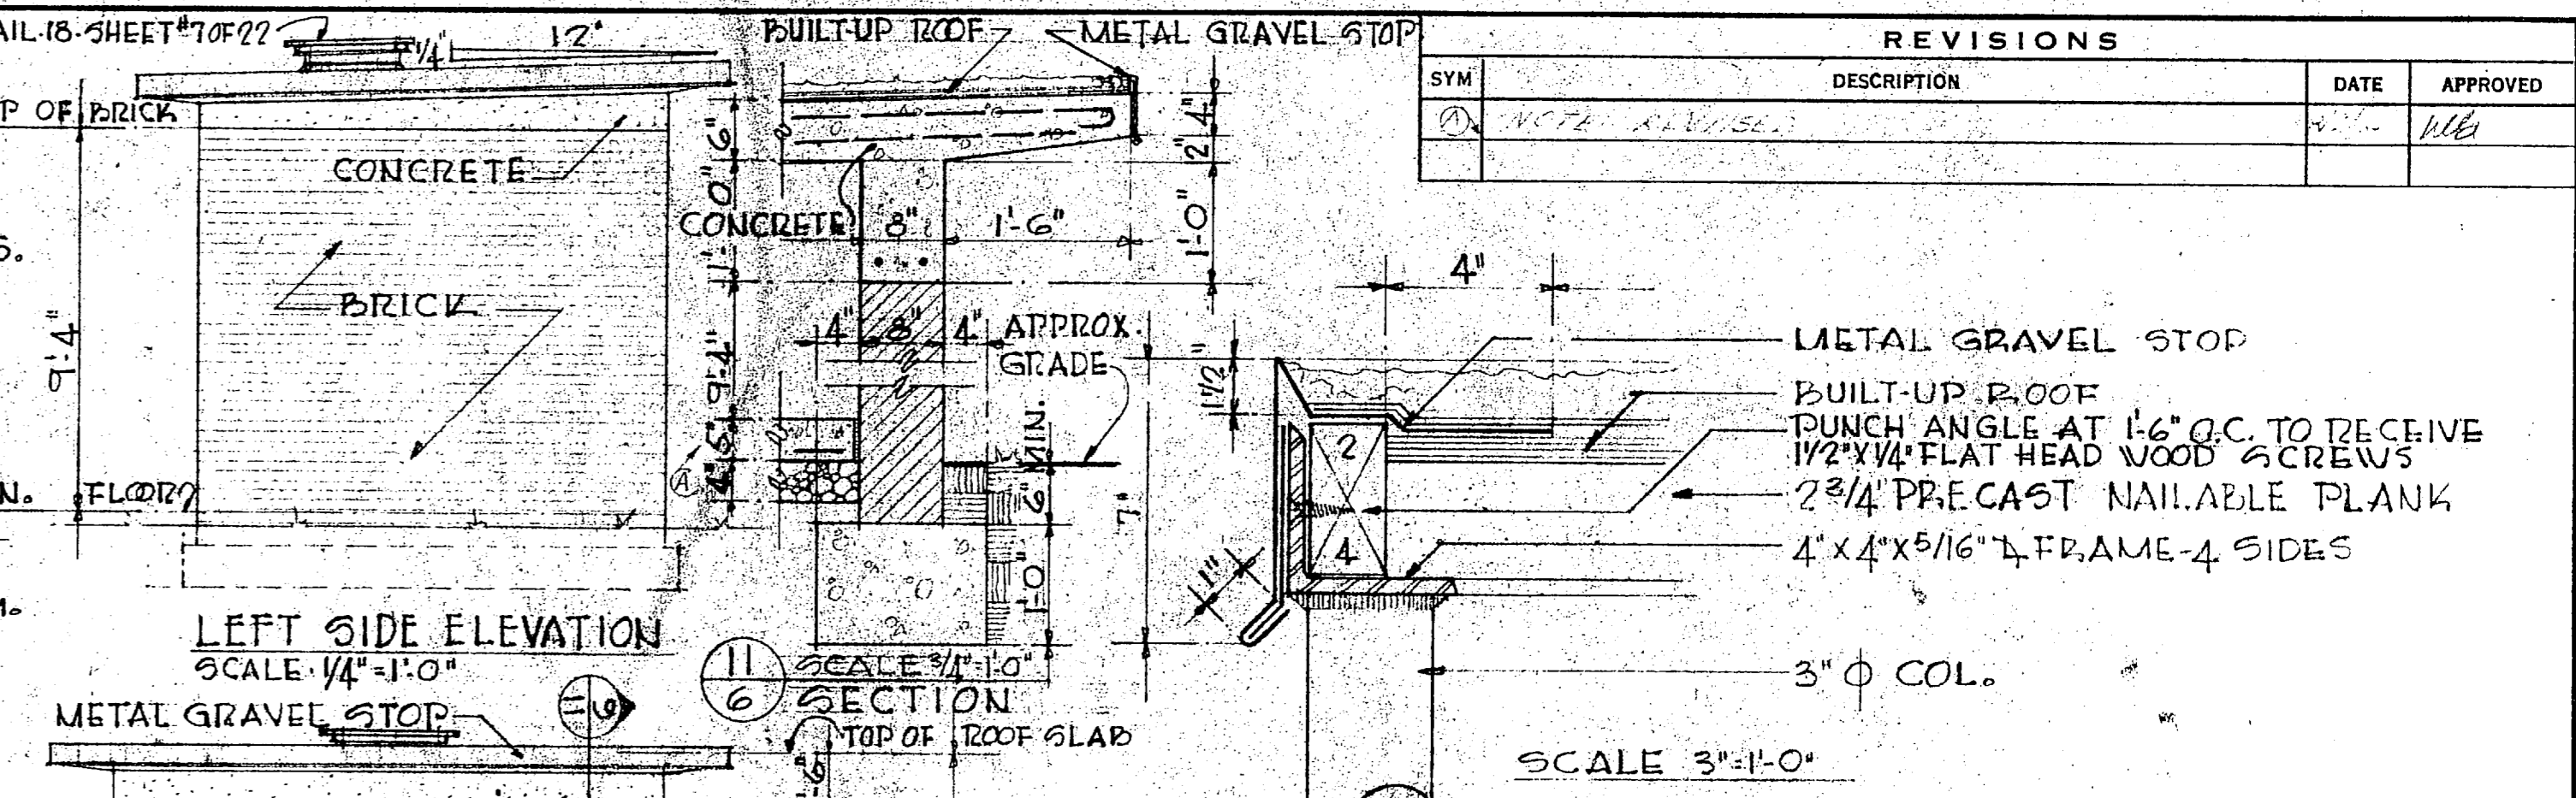


LEFT SIDE ELEVATION  
SCALE 1/8" = 1'-0"


REVISIONS			
SYM	DESCRIPTION	DATE	APPROVED
1	ADD FINISHES	1/16	

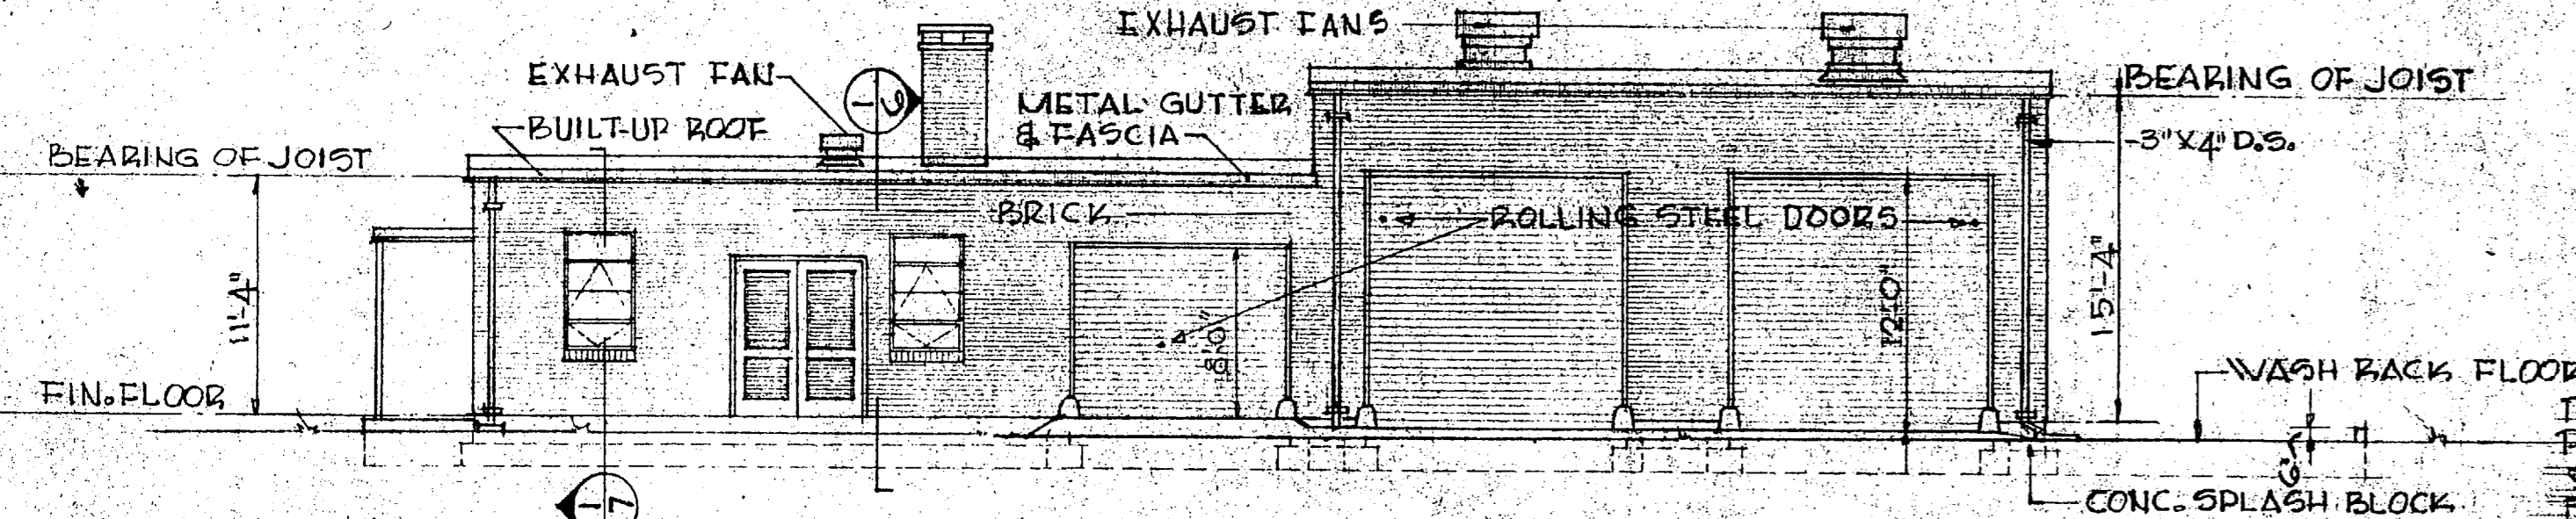


REAR ELEVATION  
SCALE 1/8" = 1'-0"

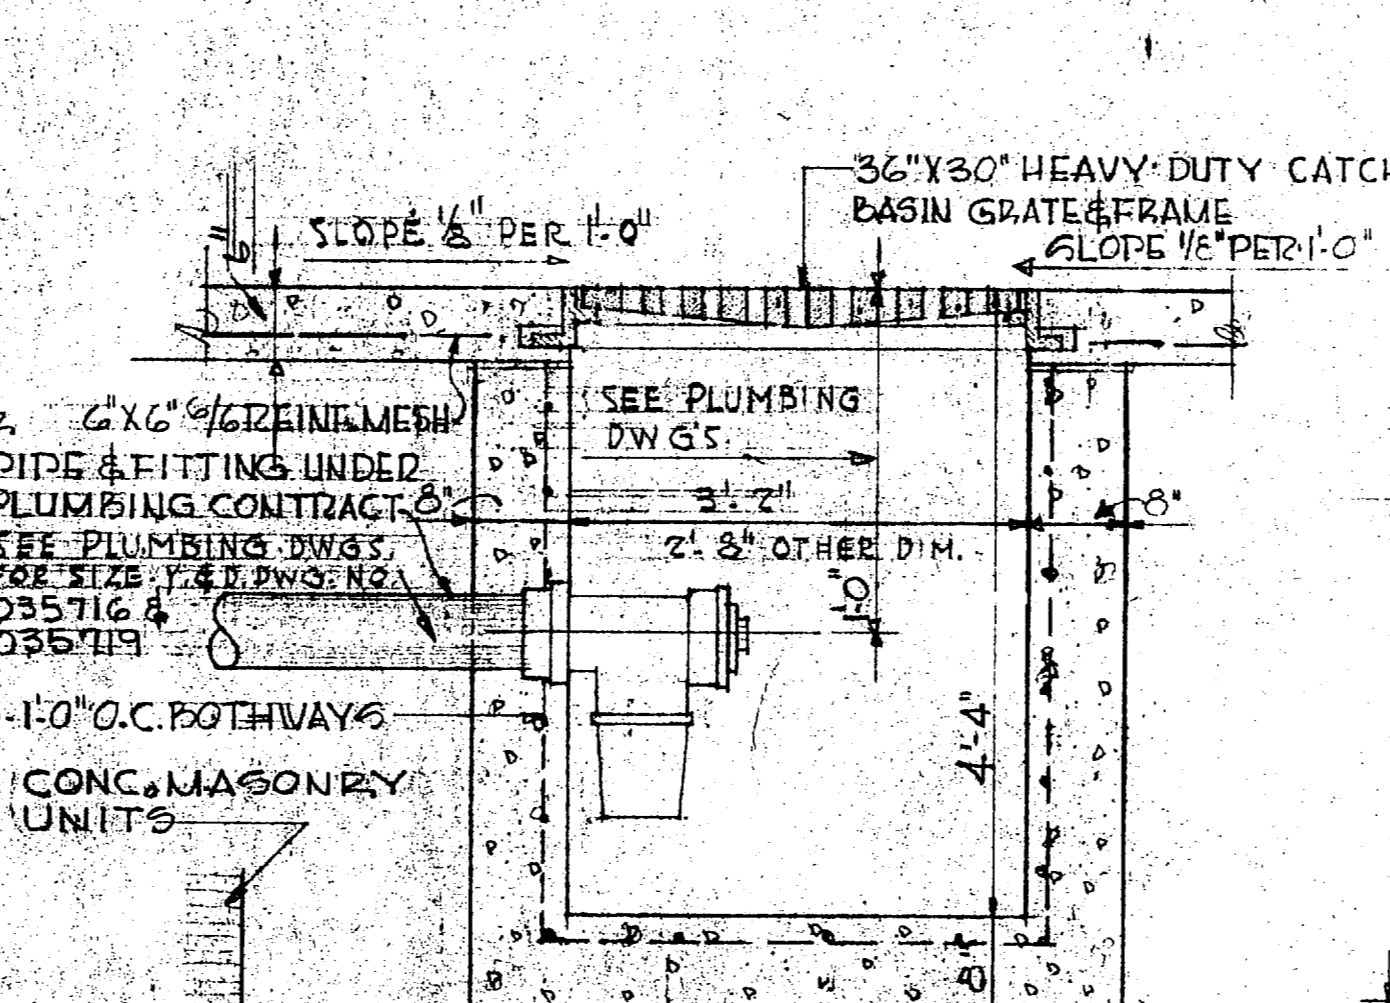


SCALE 3/4" = 1'-0"  
SAND TRAP DETAILS

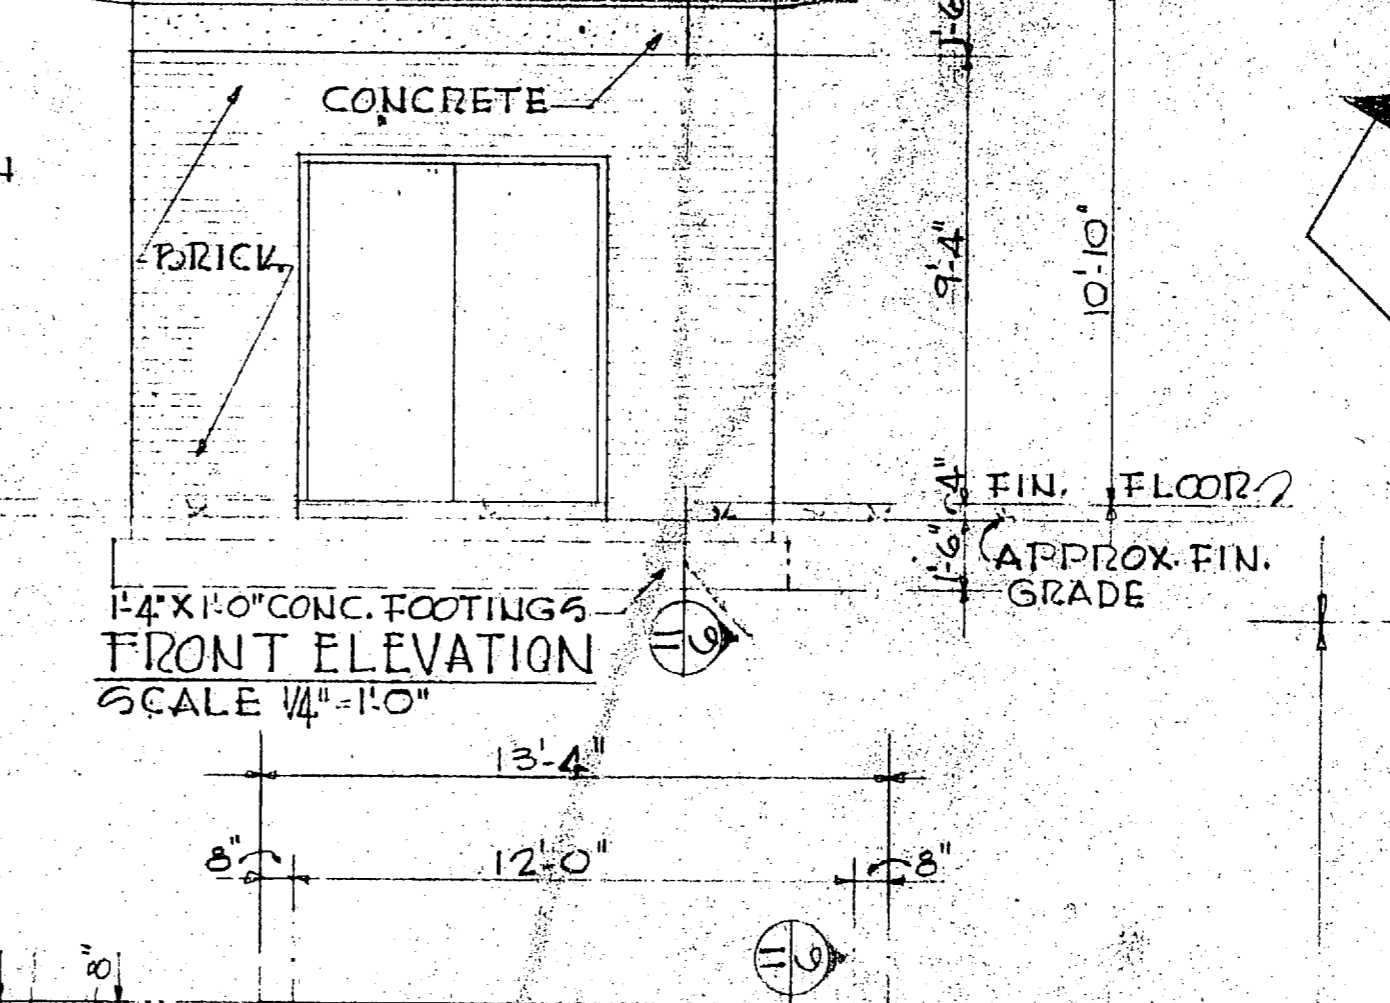


FRONT ELEVATION  
SCALE 1/8" = 1'-0"

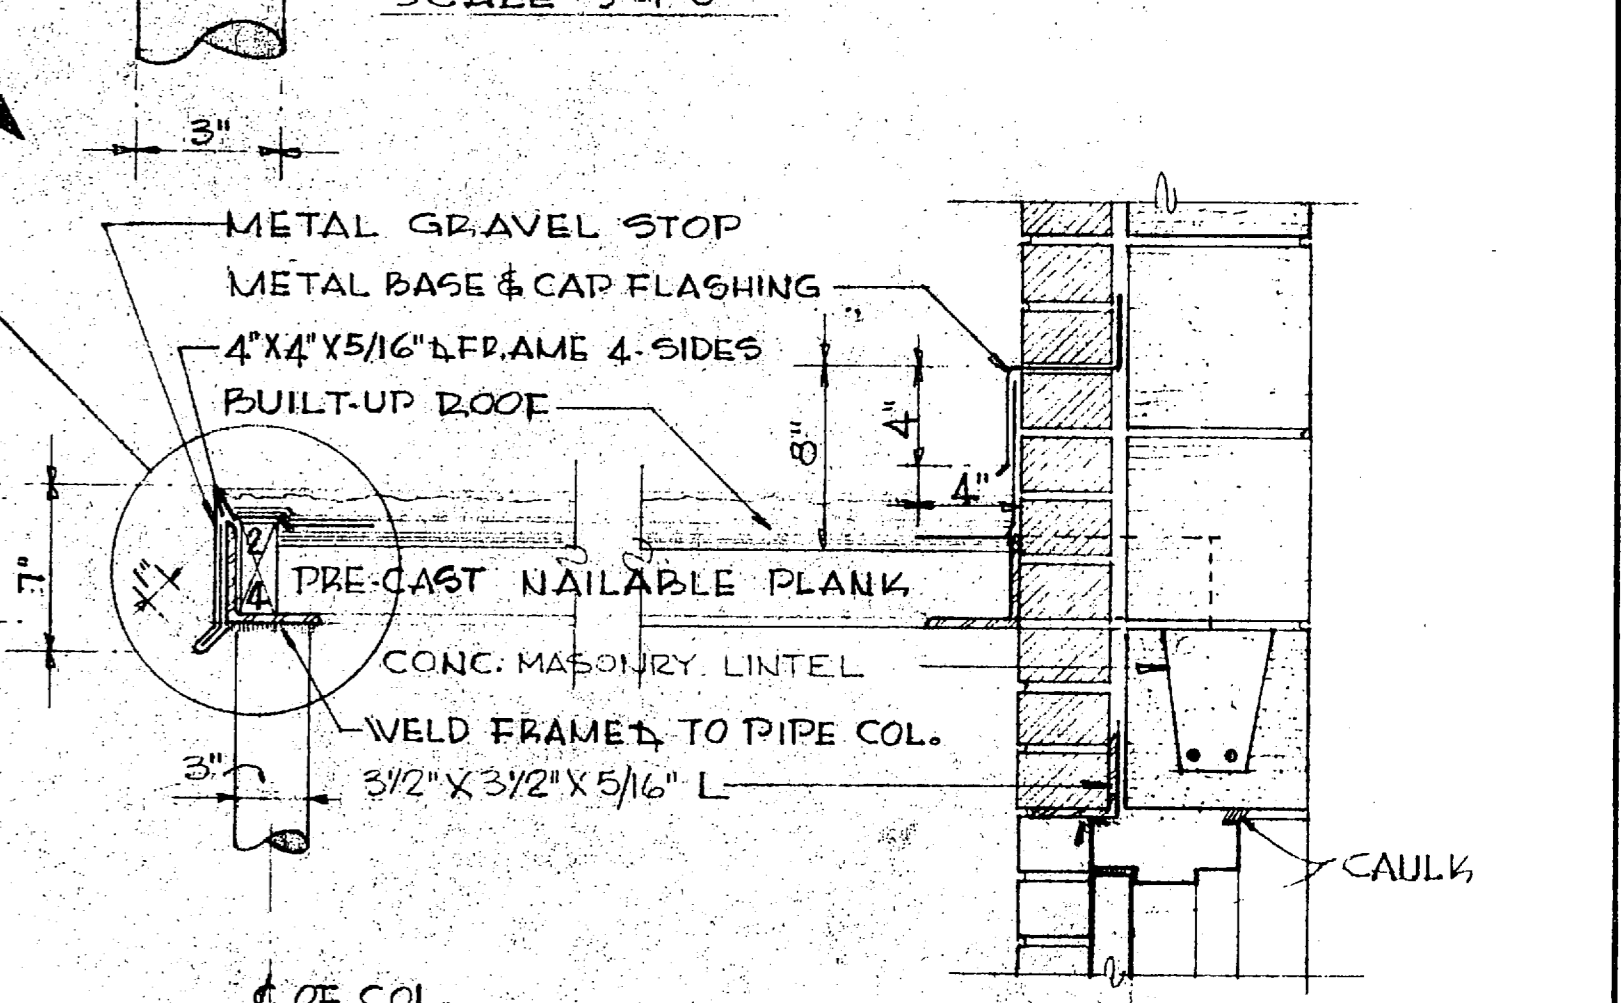


SCALE 3/4" = 1'-0"

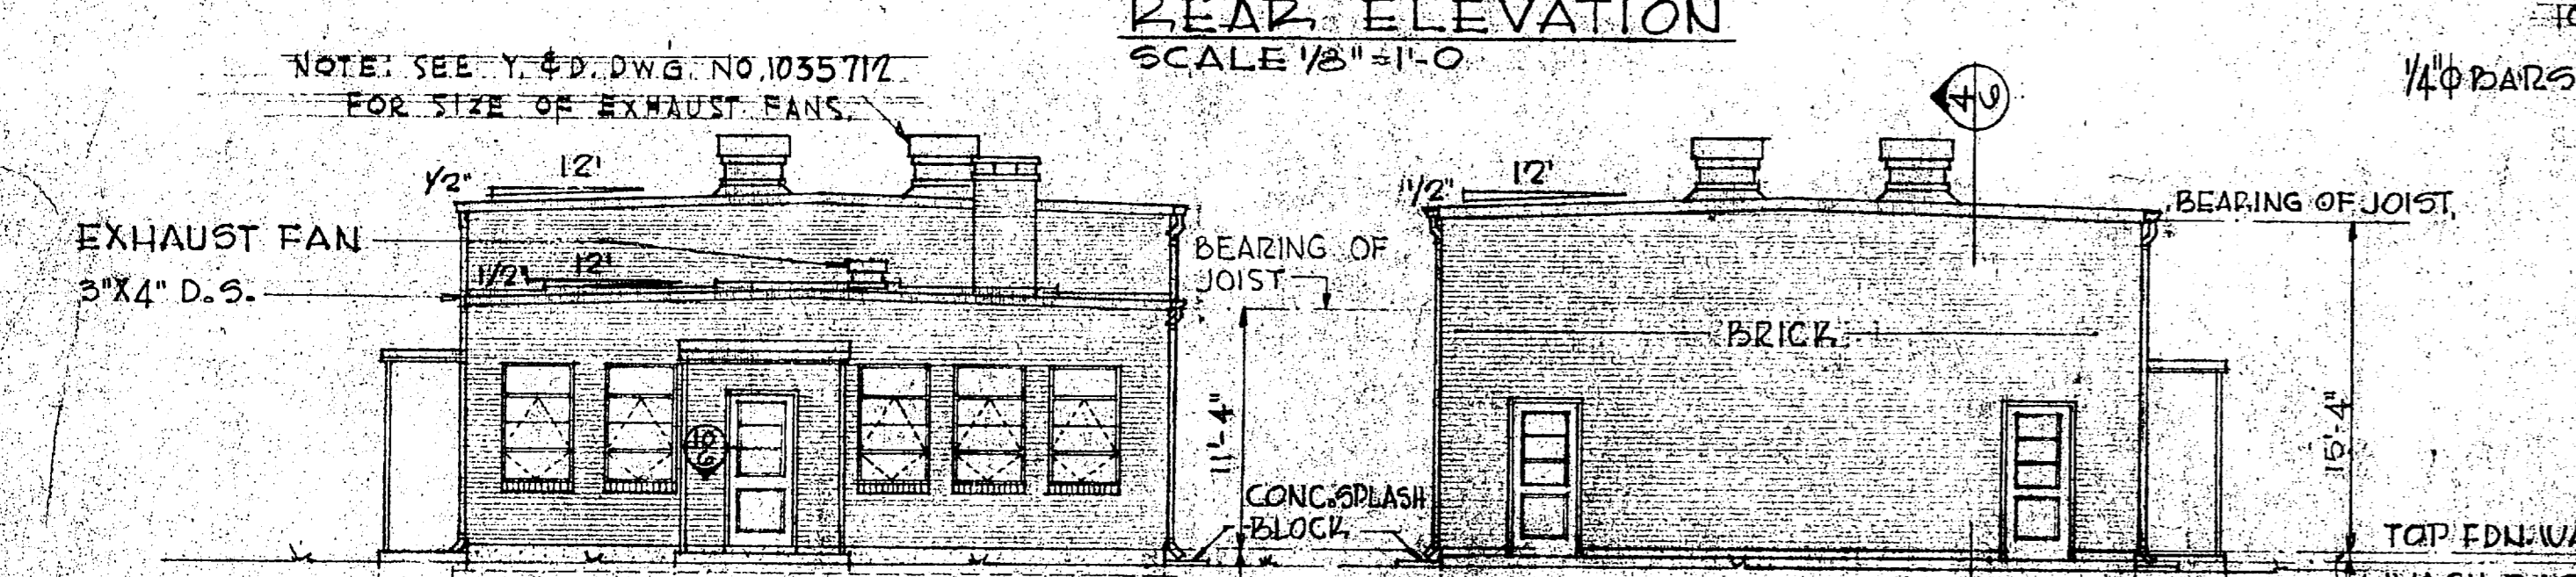


LEFT SIDE ELEVATION  
SCALE 1/8" = 1'-0"

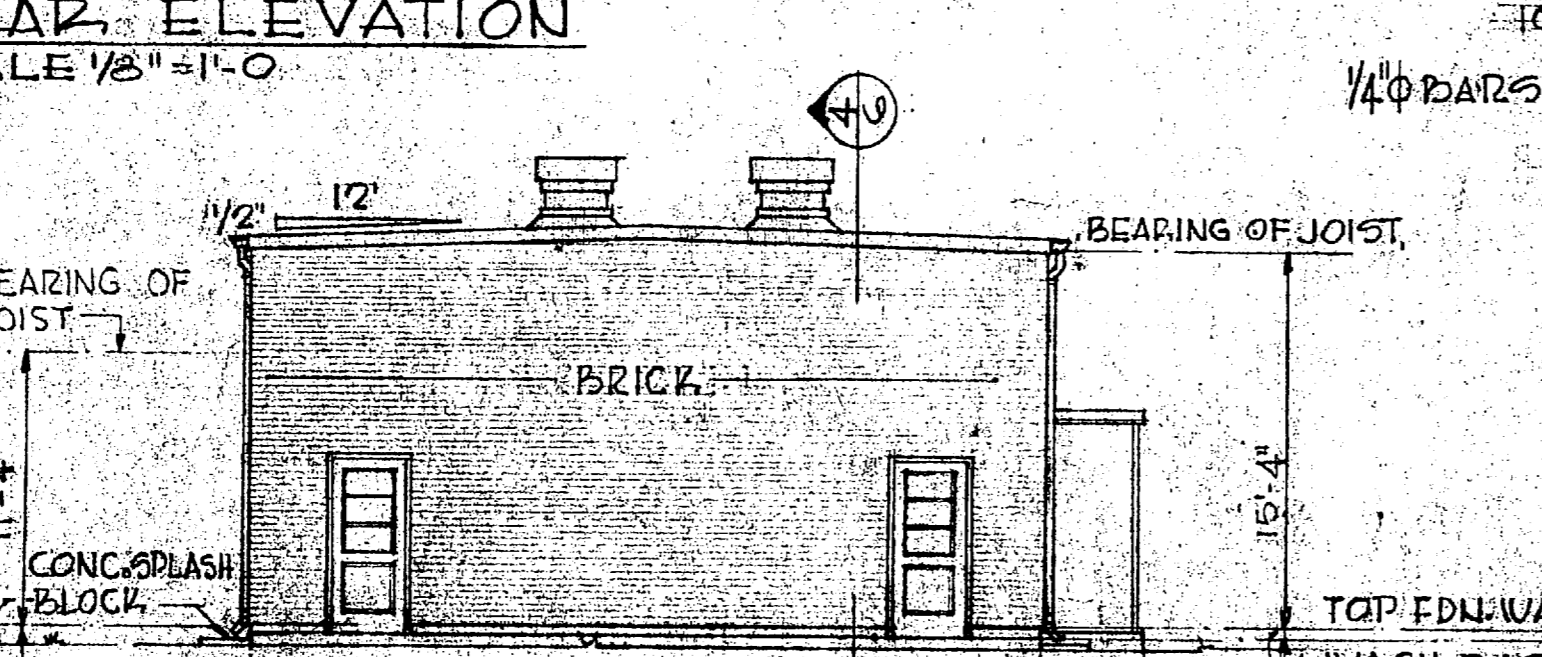


RIGHT SIDE ELEVATION  
SCALE 1/8" = 1'-0"

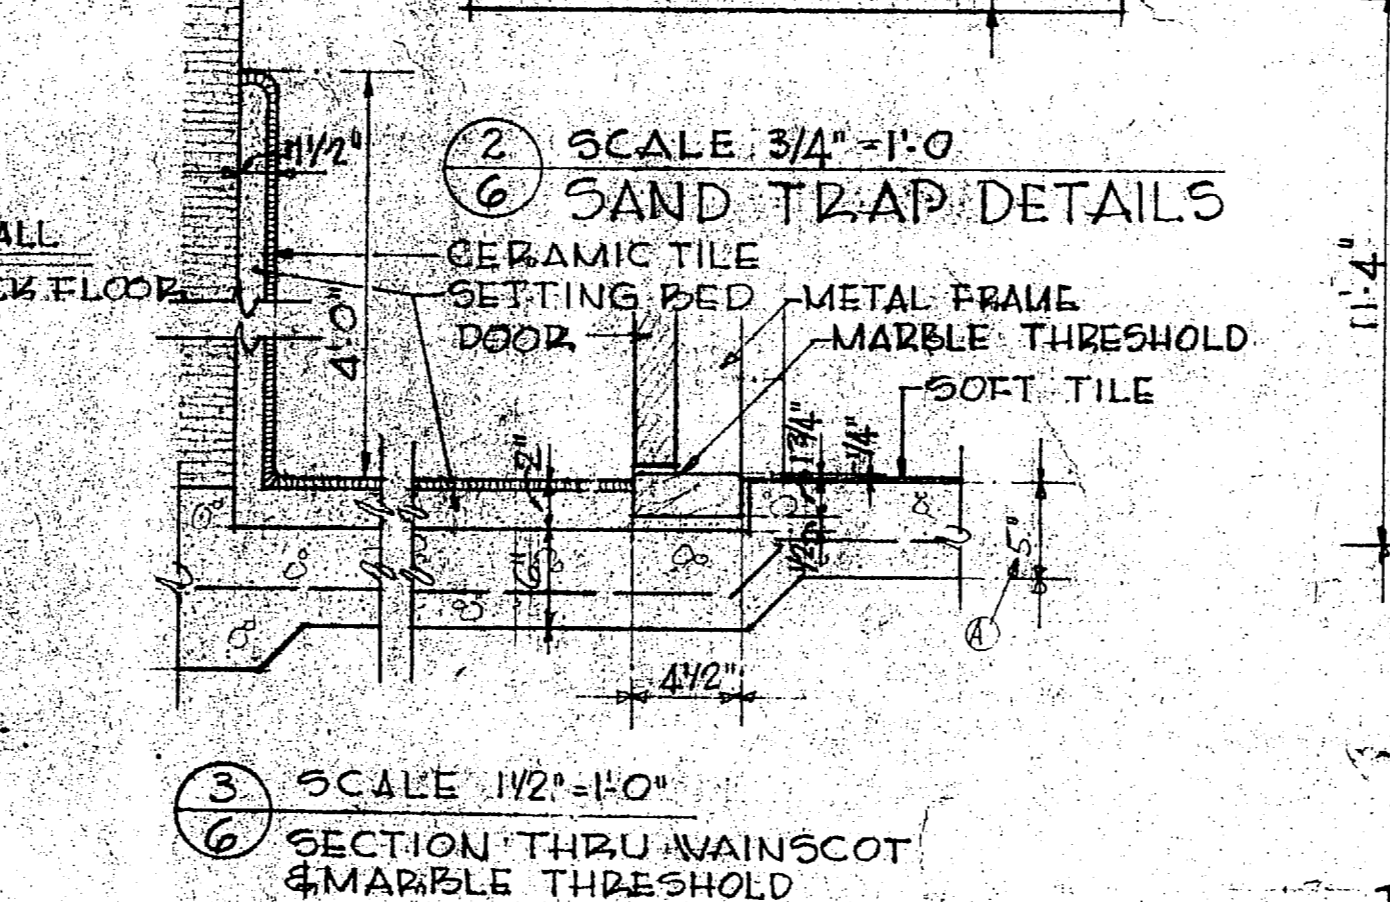


SCALE 1/2" = 1'-0"  
SECTION THRU MAINSCOT & MARBLE THRESHOLD

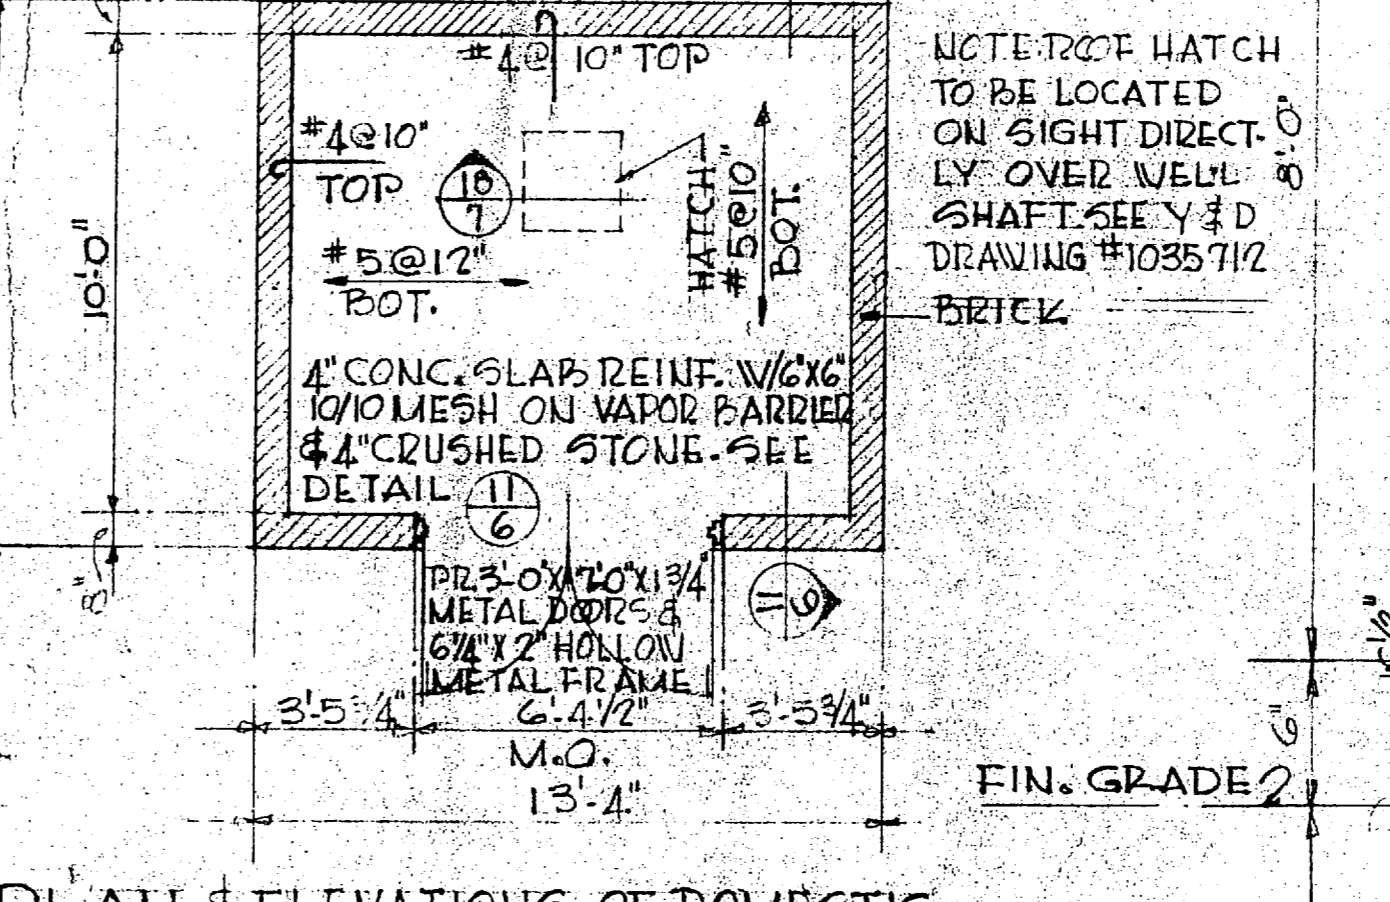


SCALE 1/4" = 1'-0"  
PLAN & ELEVATIONS OF DOMESTIC WATER WELL HOUSE

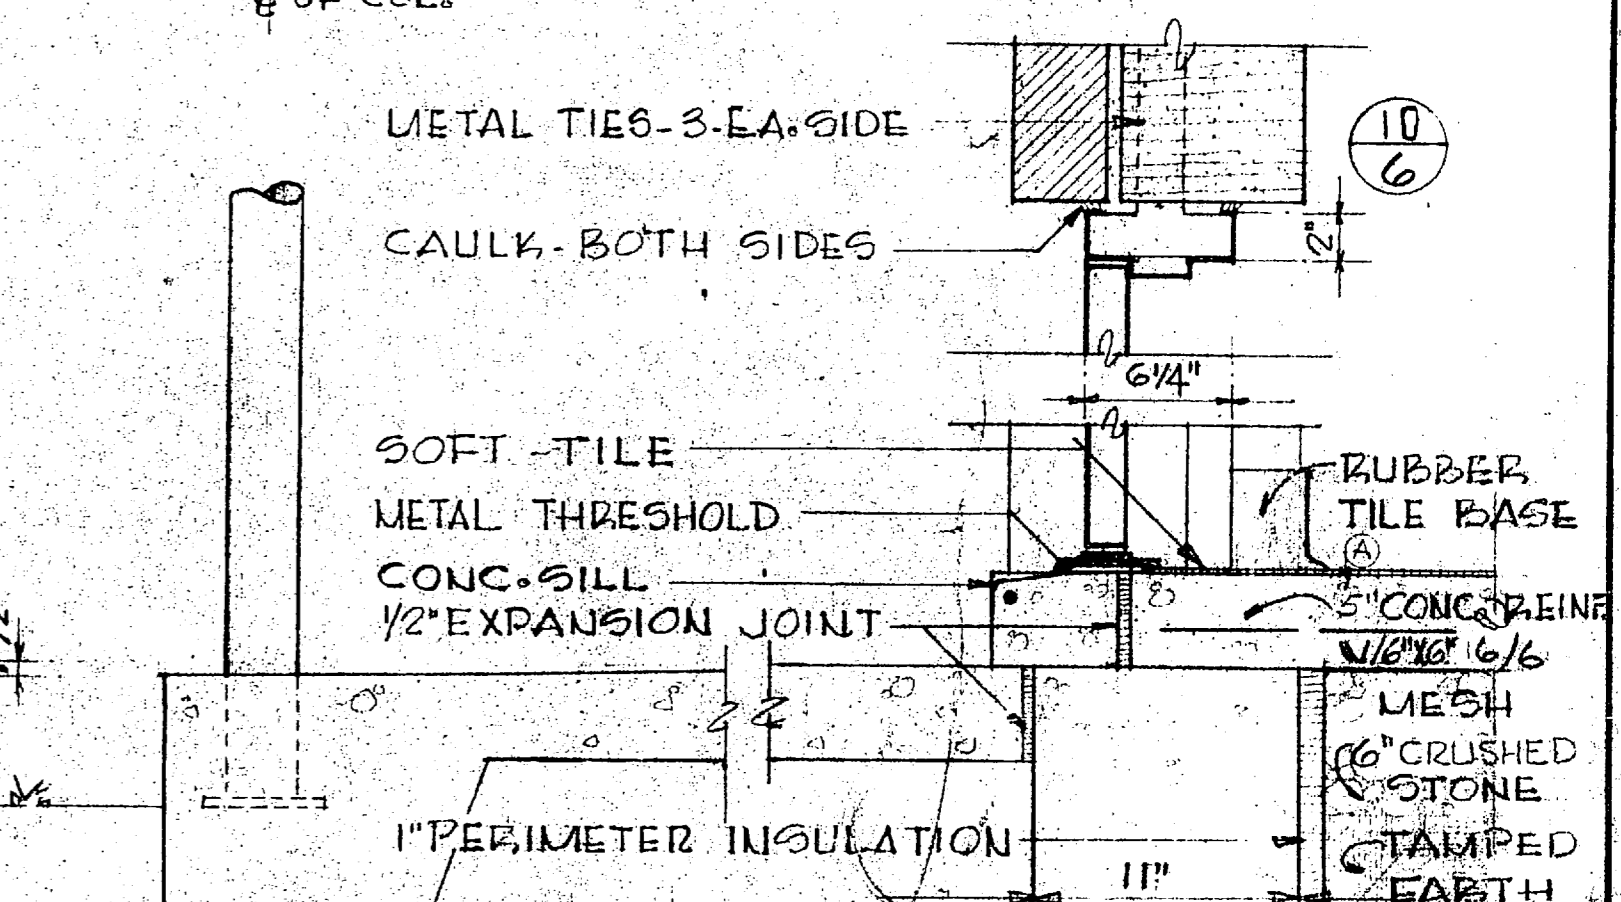


SCALE 1/2" = 1'-0"  
SECTION

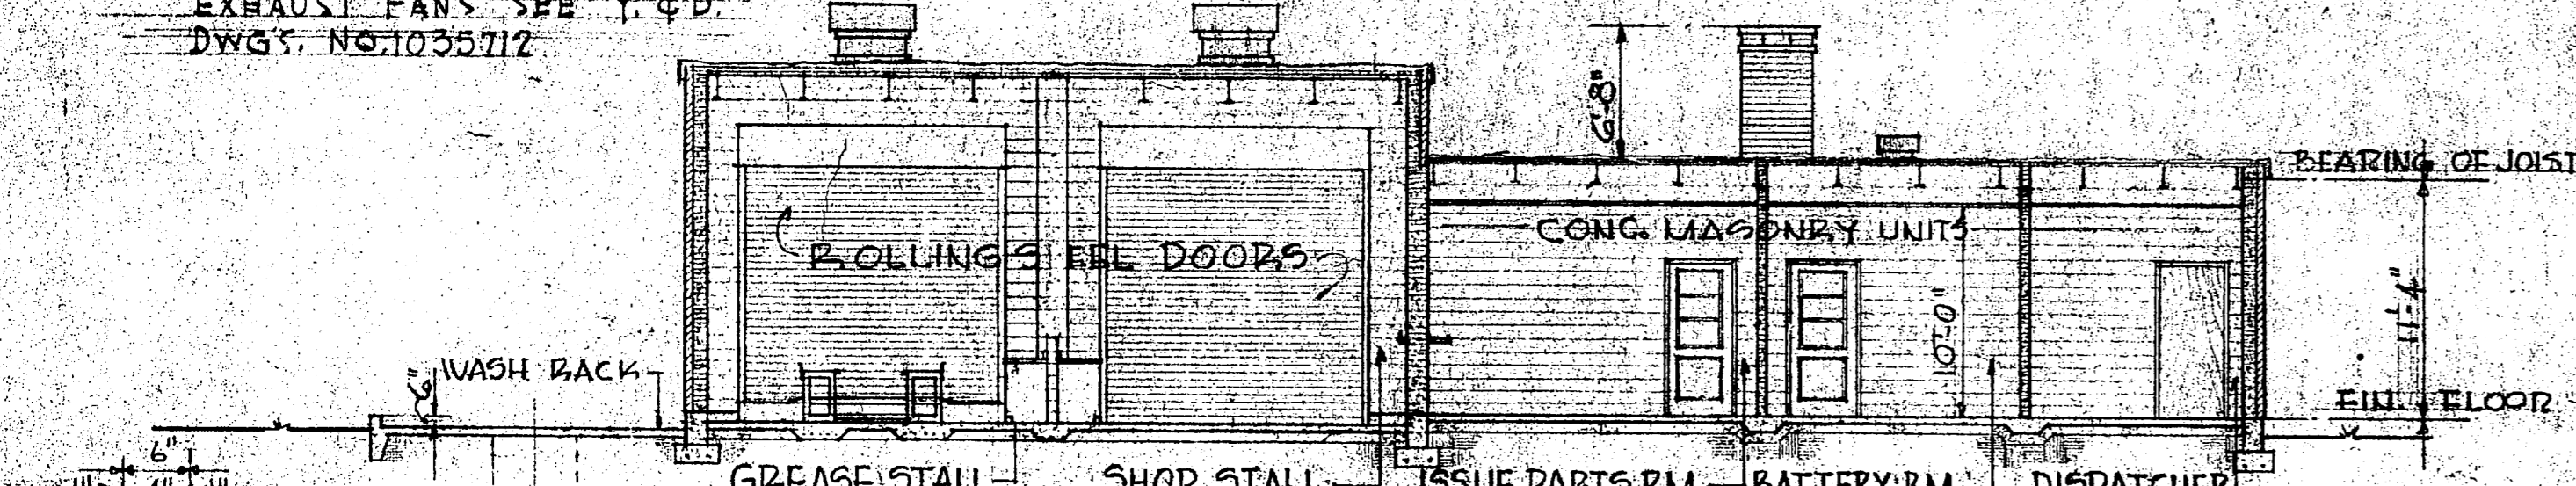


SECTION  
SCALE 1/8" = 1'-0"

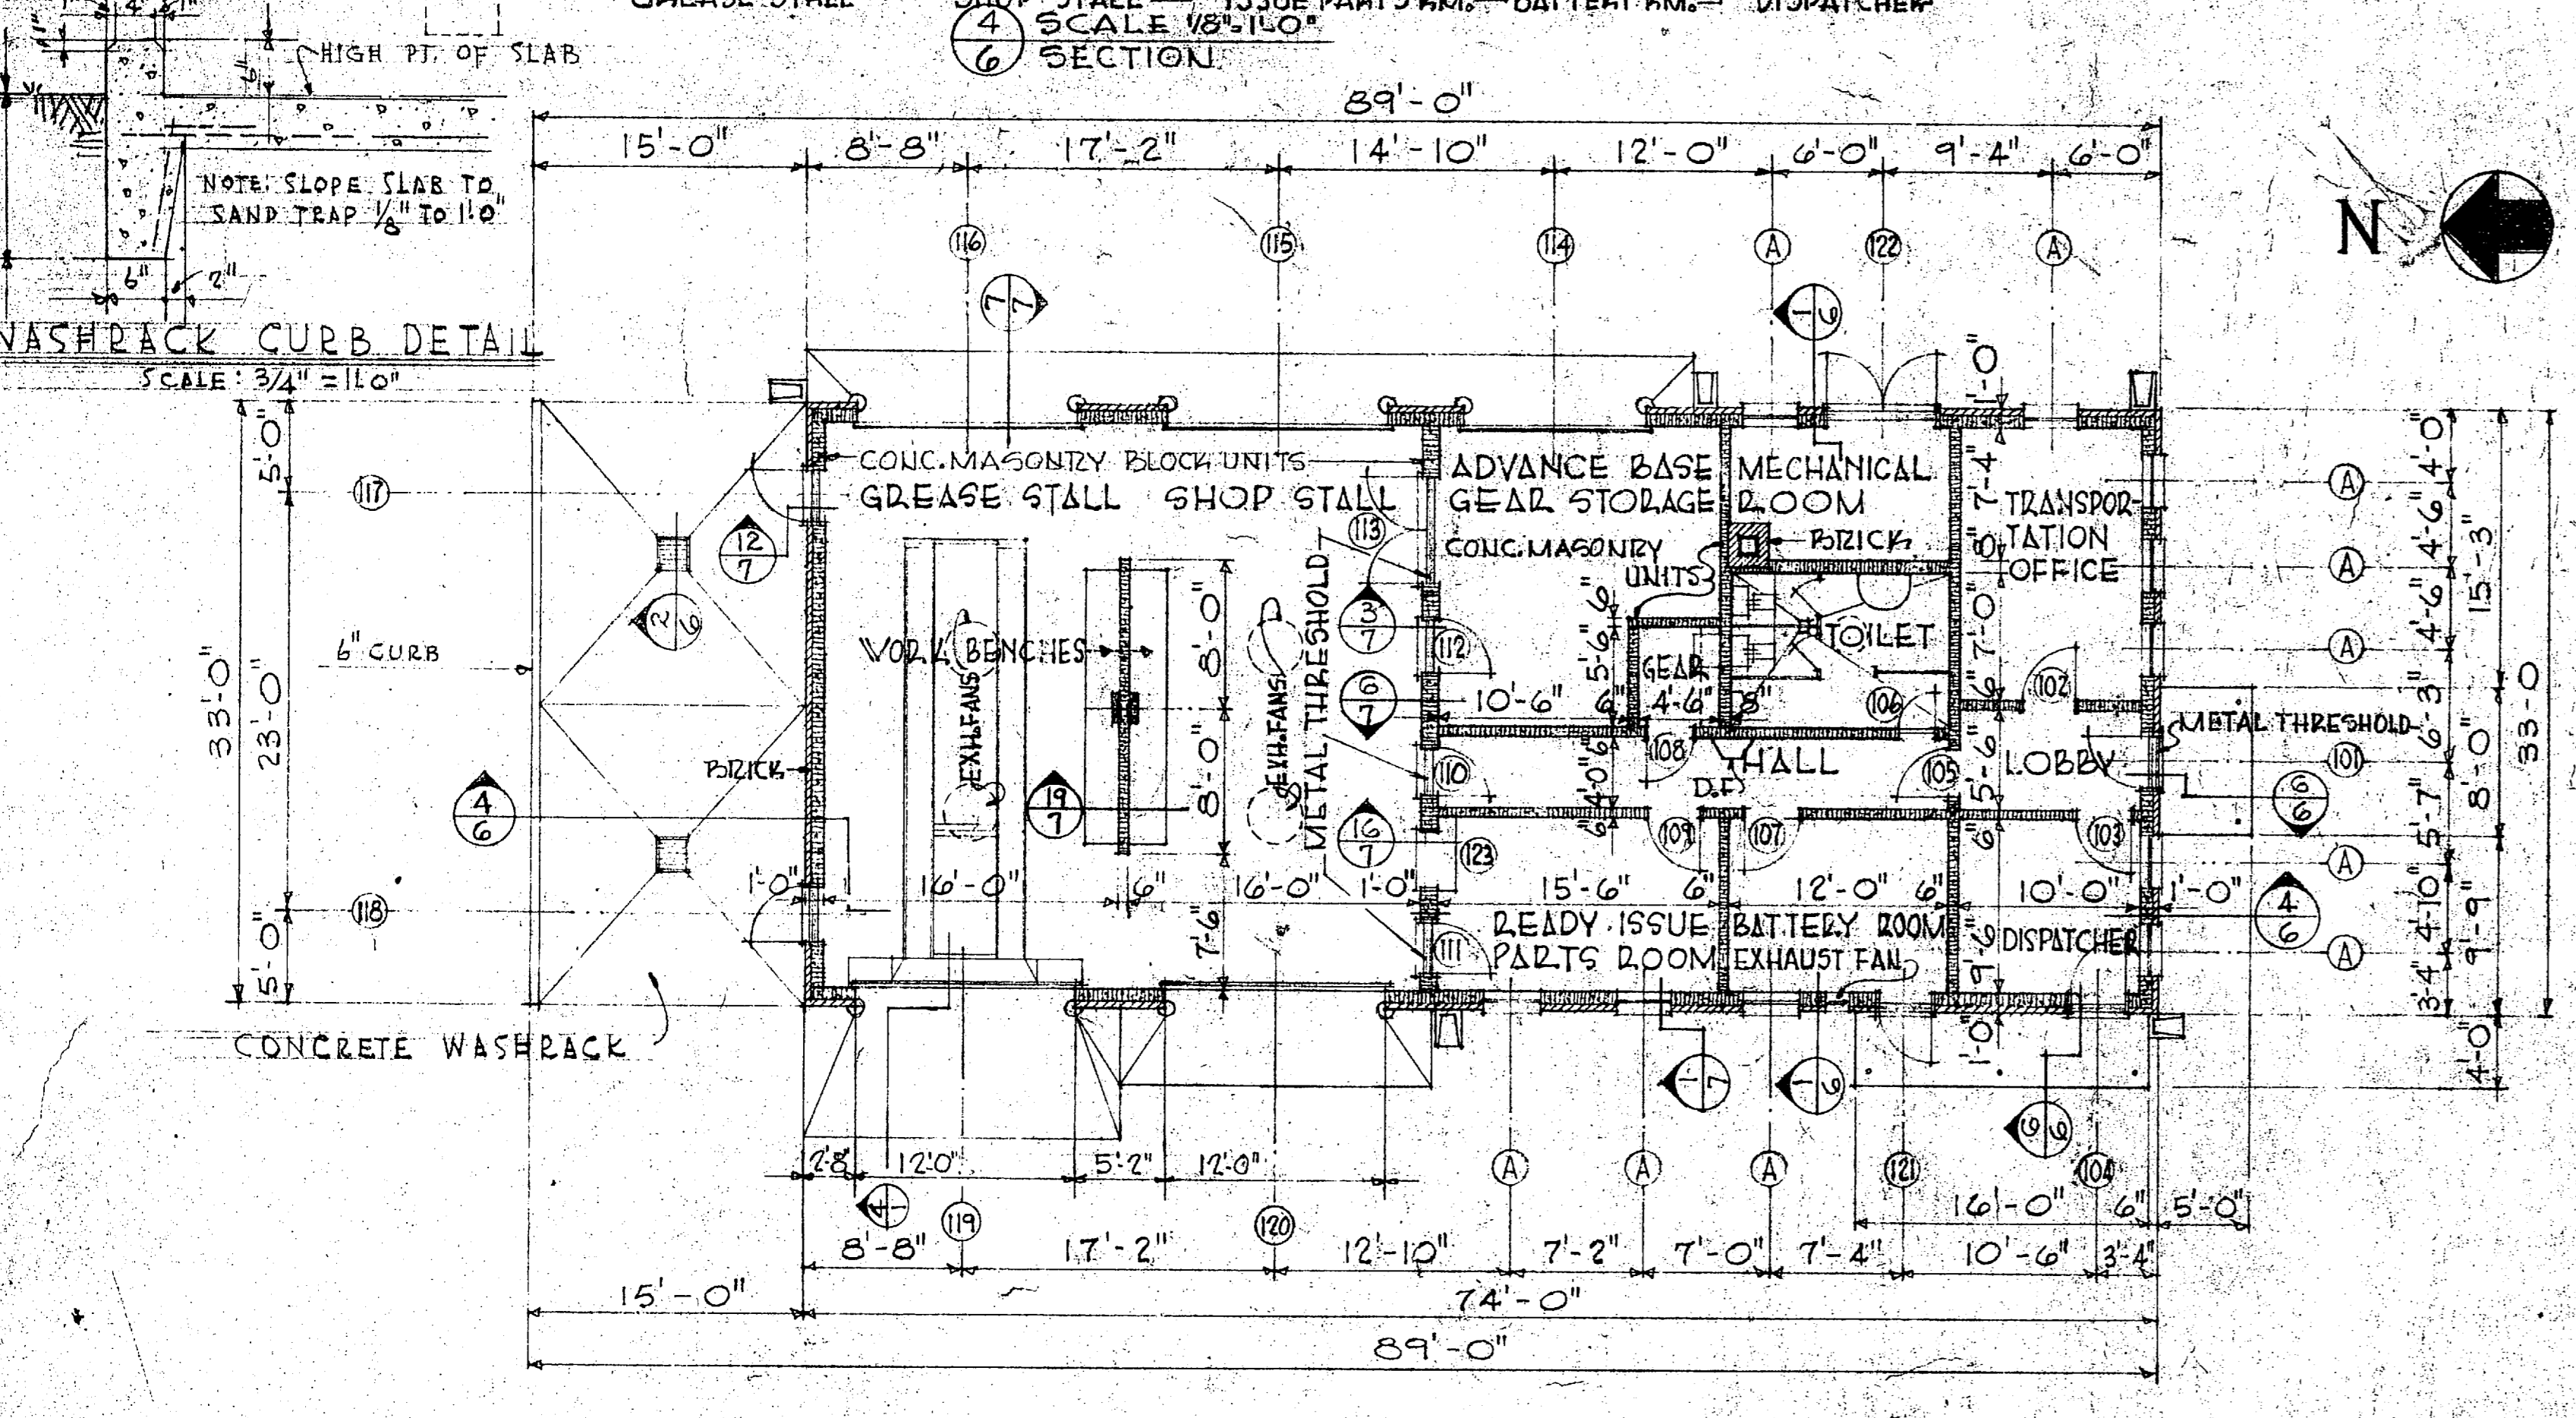


FLOOR PLAN  
SCALE 1/8" = 1'-0"

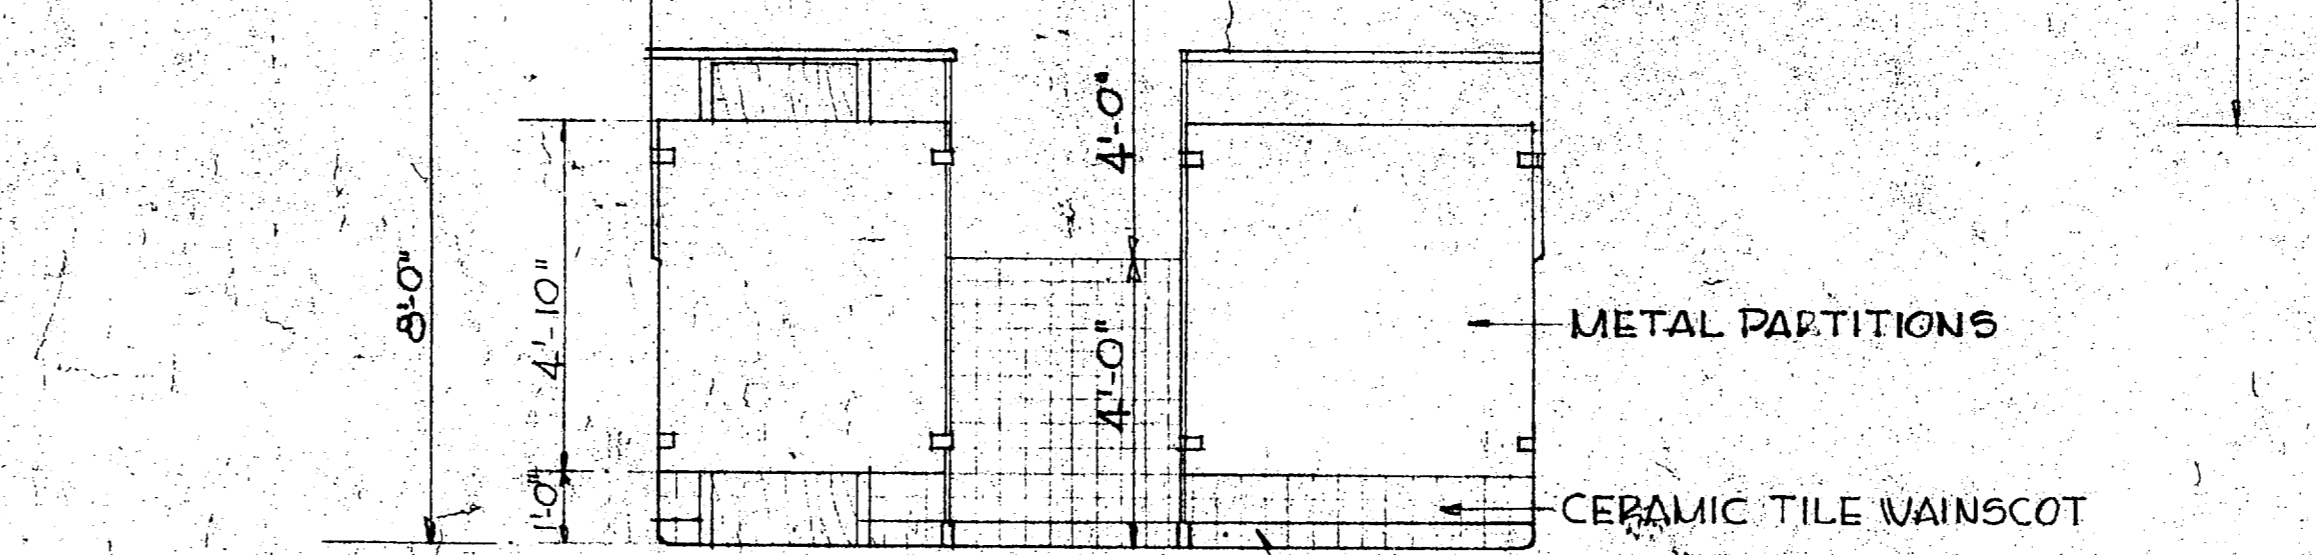

SCALE 3/8" = 1'-0"  
TOILET ELEVATION

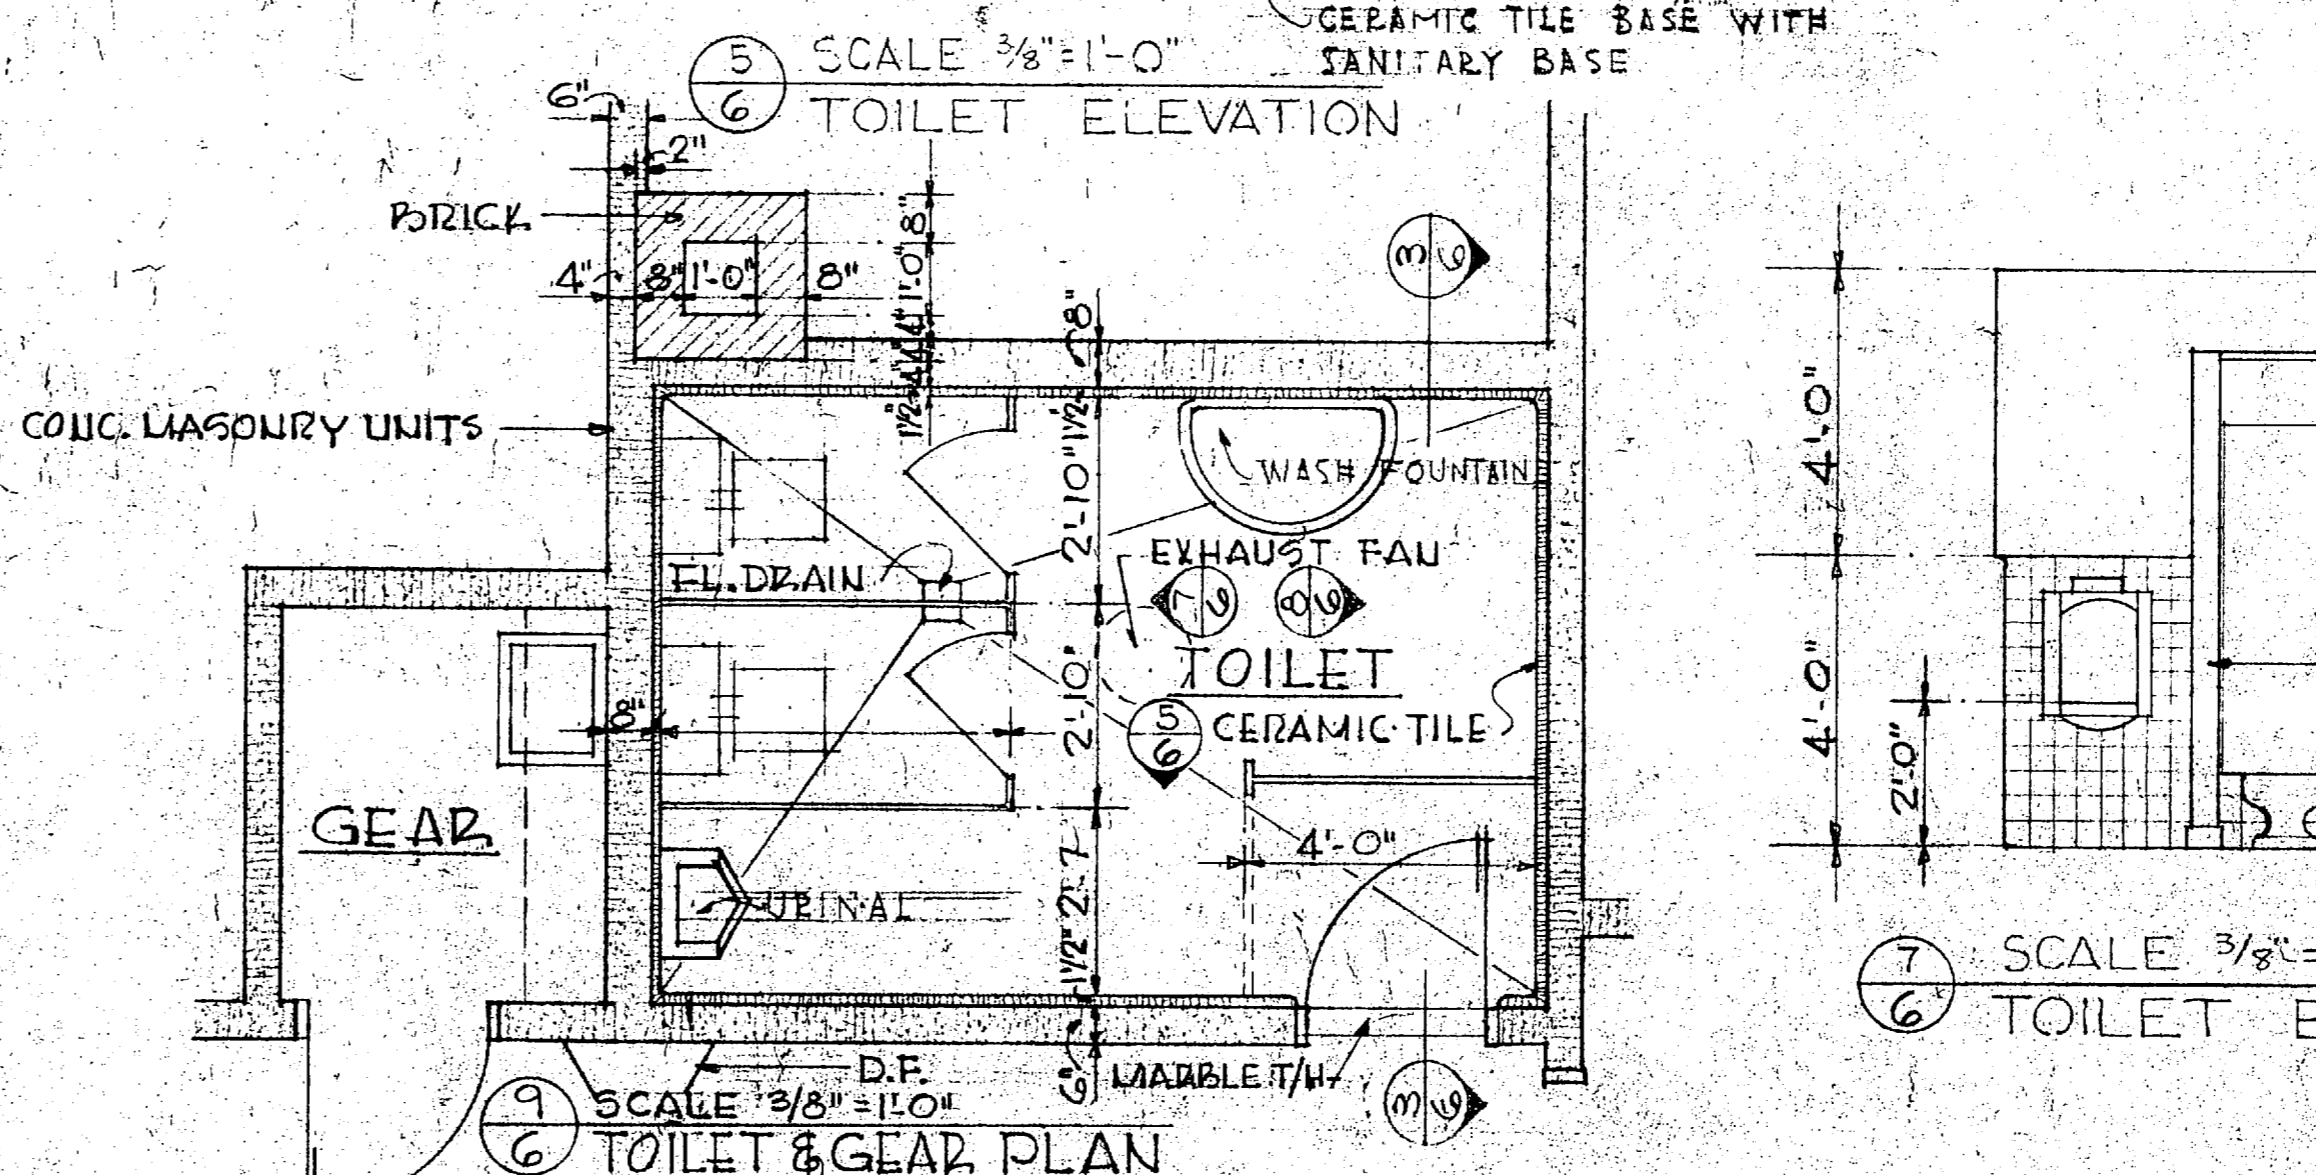


SCALE 3/8" = 1'-0"  
TOILET & GEAR PLAN

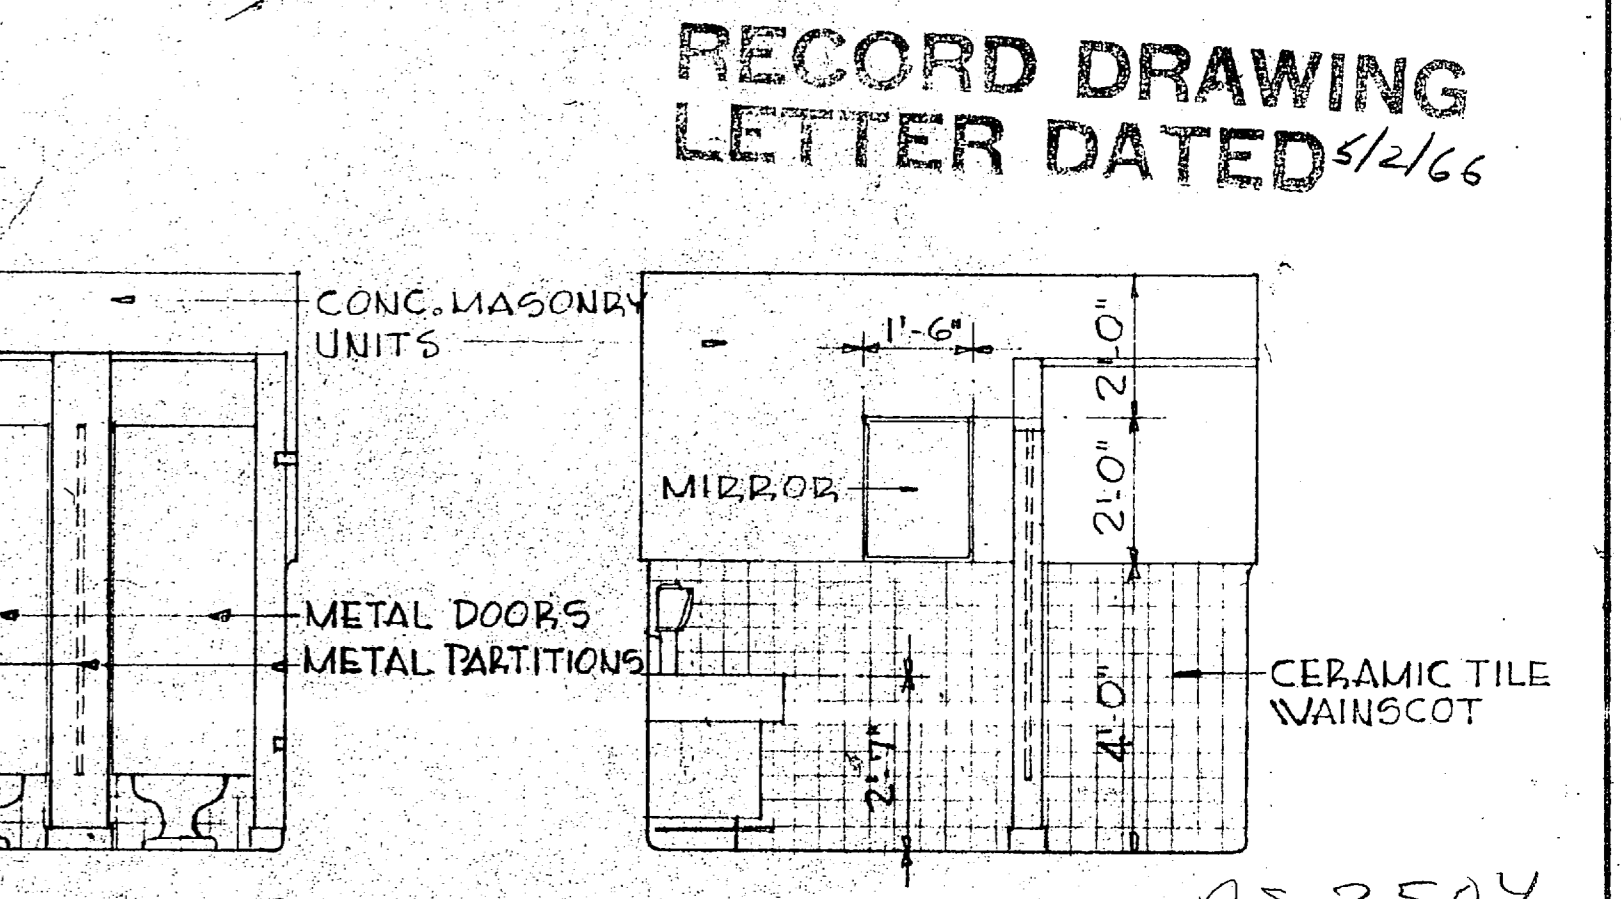


SCALE 3/8" = 1'-0"  
TOILET ELEVATION

SCALE 3/8" = 1'-0"  
TOILET ELEVATION

RECORD DRAWING  
LETTER DATED 1/16/66

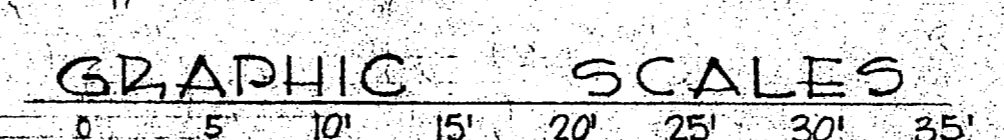

GRAPHIC SCALES

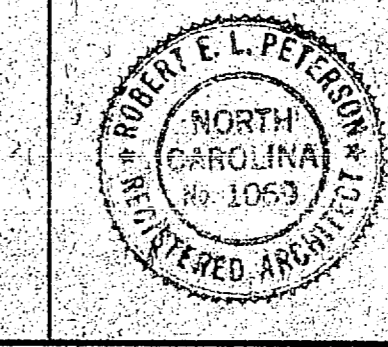

ROBERT E. L. PETERSON AIA GREENSBORO, NORTH CAROLINA ARCHITECTS	DEPARTMENT OF THE NAVY BUREAU OF YARDS & DOCKS ATLANTIC DIVISION NORFOLK, VIRGINIA
DES. LEE   DR. G. DD   CHK. E. LD PROJ. MGR. B. E. LD	U.S. MARINE CORPS AIR FACILITY NEW RIVER, JACOBSONVILLE, NORTH CAROLINA
SUBMITTED BY: ROBERT E. L. PETERSON DATE: 1/16/66 OWNER: PRINCIPAL	MACS COMBAT EQUIPMENT MAINTENANCE SHOP FLOOR PLAN, EXTERIOR ELEVATIONS, DETAILS, SECTIONS, TOILET PLAN & ELEVATIONS
DRAWN BY: RVD, F.L. DATE: 1/16/66 BR. MGR. B. E. LD, ENG. DIR. C. E. LD	SCALE IDENT. NO. 80091 F SIZE 10 3/4 x 14 1/2
SHEET 6 OF 21	SHEET 6 OF 21

