

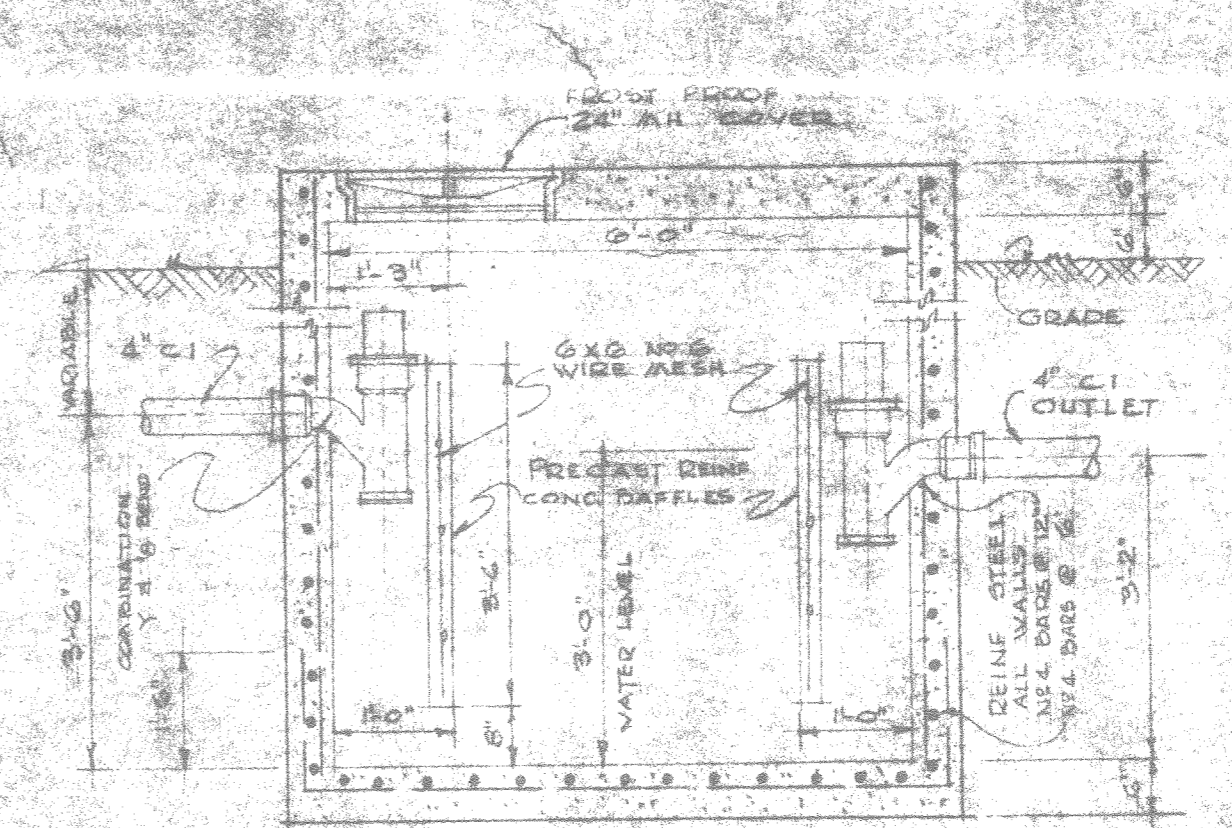


SCHEDULE OF SYMBOLS

	WASTE PIPING	W. DN.	WASTE DOWN
	COLD WATER PIPING		GATE VALVE
	HOT WATER PIPING		CHECK VALVE
	RECIRCULATING (HW)		CLEAN OUT ABOVE FLOOR
	VENT THROUGH ROOF		CLEAN OUT IN FLOOR
	DRINKING FOUNTAIN		FLOOD DRAIN

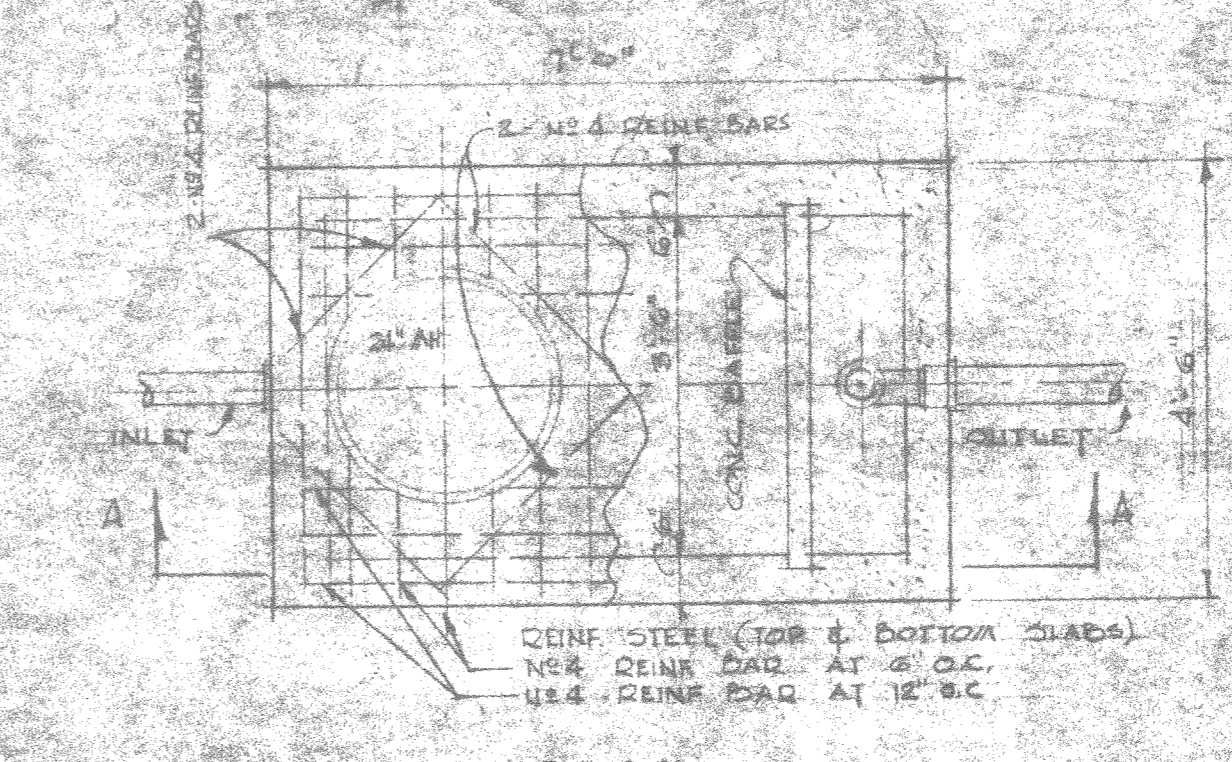


SECTION A-A  
TYPICAL GREASE TRAP DETAIL  
SCALE 1/2" = 1'-0"

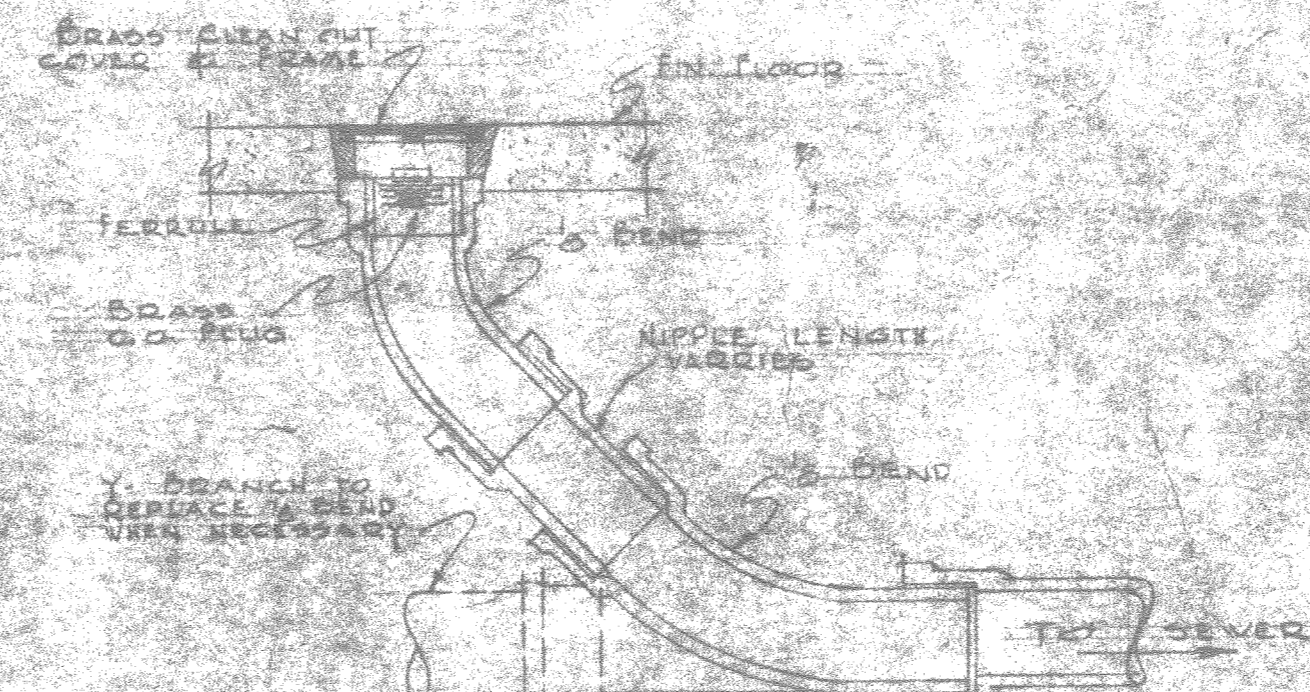

TYPICAL FLOOR CLEANOUT DETAIL  
NO SCALE

NOTE  
PIPE CLEANERS ARE TO BE KEPT IN FLOOR  
TRAPS FOR ALL PIPES  
THE FULL SEALS TO BE CONTACTED BEFORE  
ANY PIPE TECHNIQUES ARE USED


TYPICAL DETAIL OF WATER CONNECTIONS TO  
INSTANTANEOUS HEATER IN MACHINE ROOM NO. 1 & 2  
NO SCALE

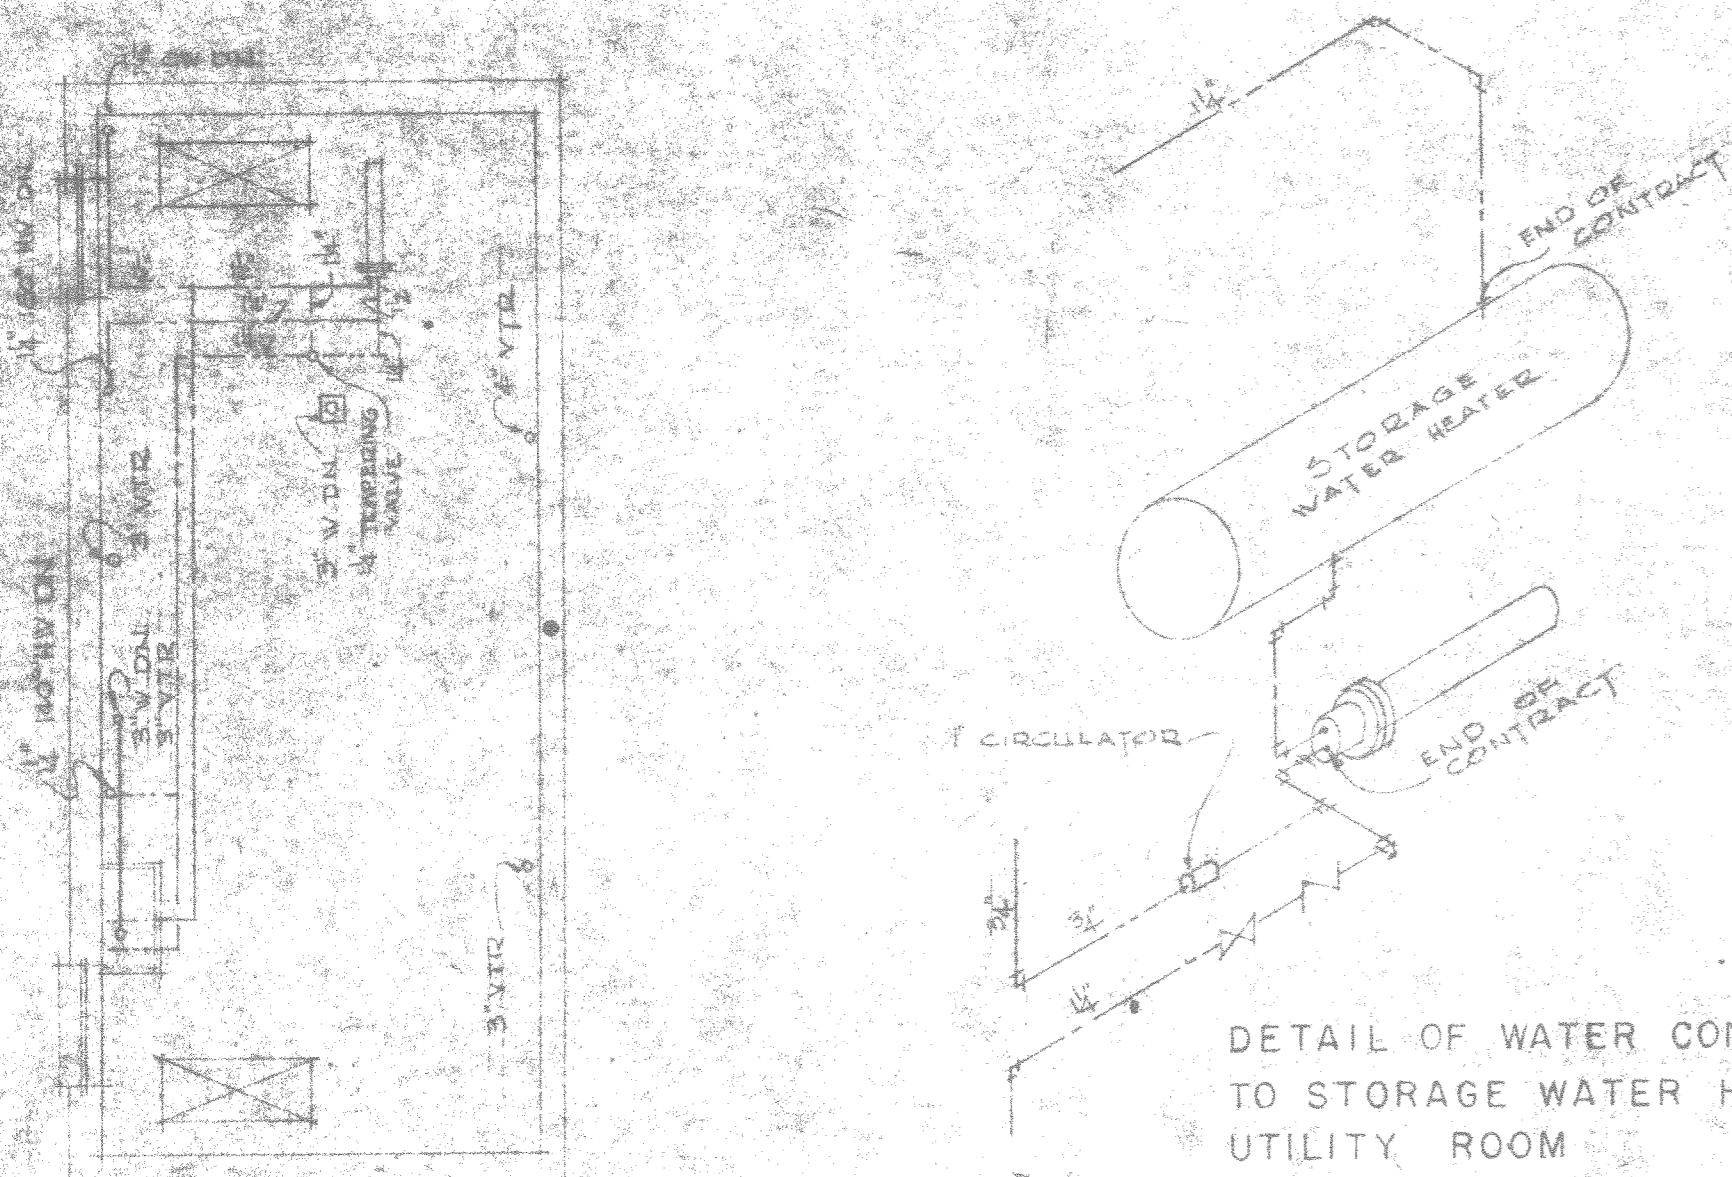


DETAIL OF WATER CONNECTIONS  
TO STORAGE WATER HEATER IN  
UTILITY ROOM  
NOT TO SCALE

FLOOR PLAN MACHINE ROOM NO. 1  
1/8" = 1'-0"


FLOOR PLAN MACHINE ROOM NO. 2  
1/8" = 1'-0"

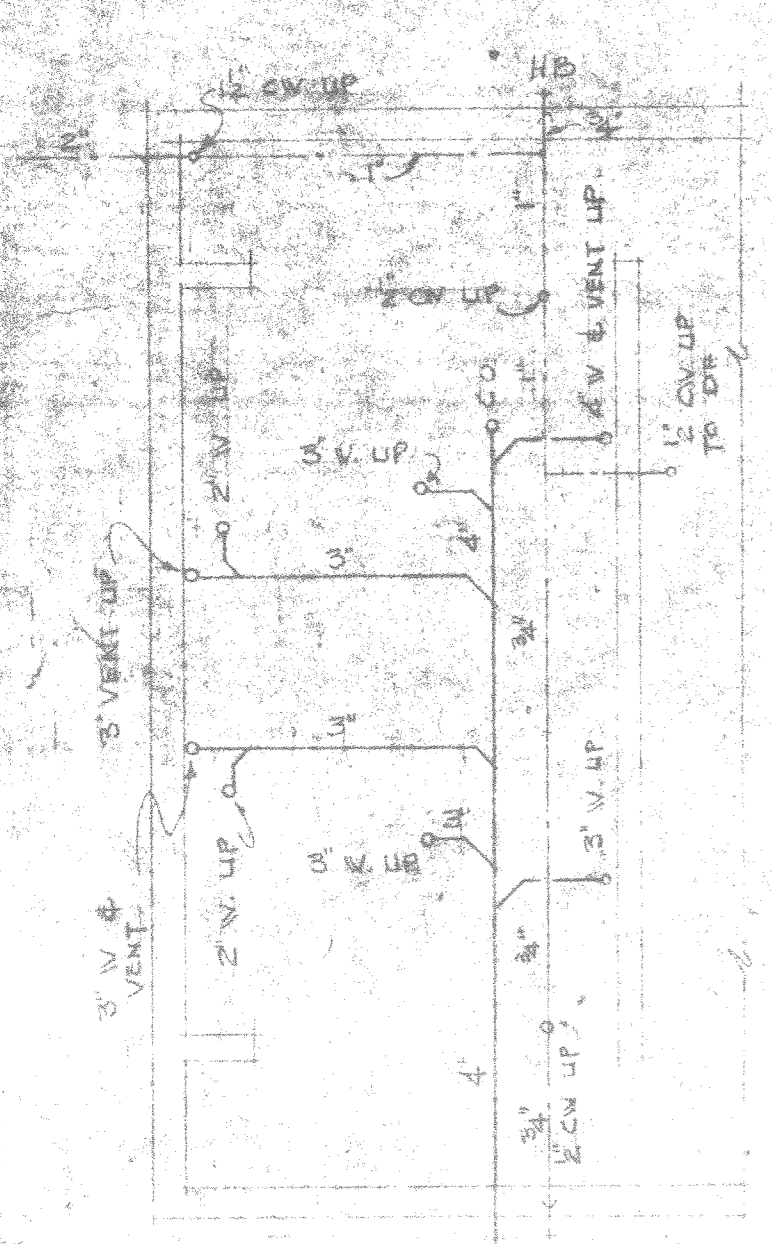


UNDERFLOOR PLAN  
GALLEY NO. 1  
1/8" = 1'-0"

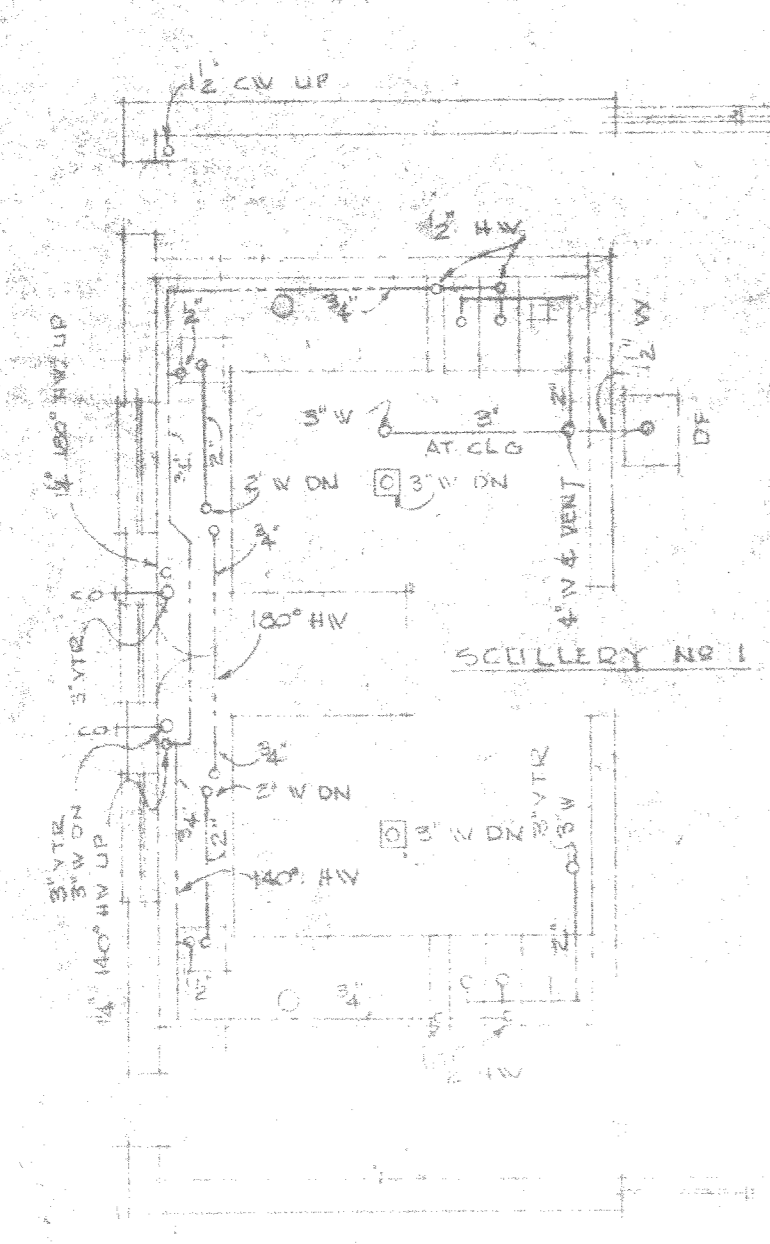


UNDERFLOOR PLAN  
SCULLERY NO. 1  
1/8" = 1'-0"

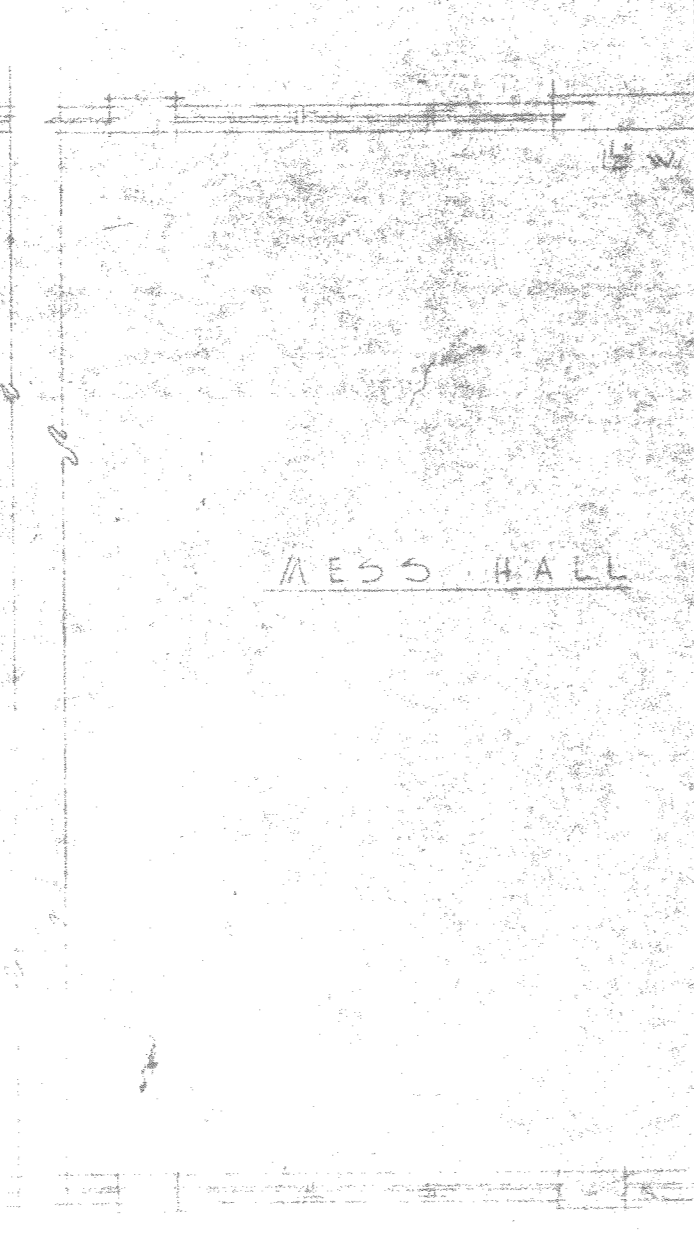


UNDERFLOOR PLAN  
MESS HALL  
1/8" = 1'-0"

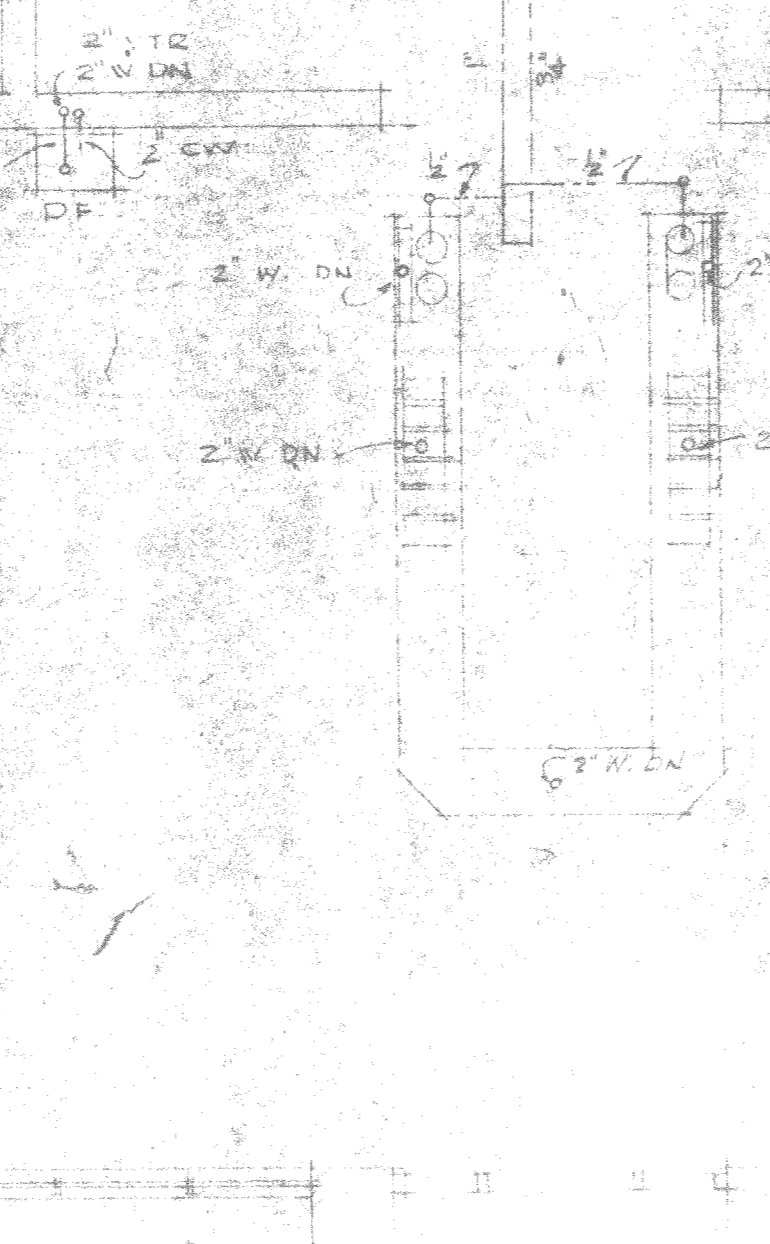


UNDERFLOOR PLAN  
MESS HALL  
1/8" = 1'-0"

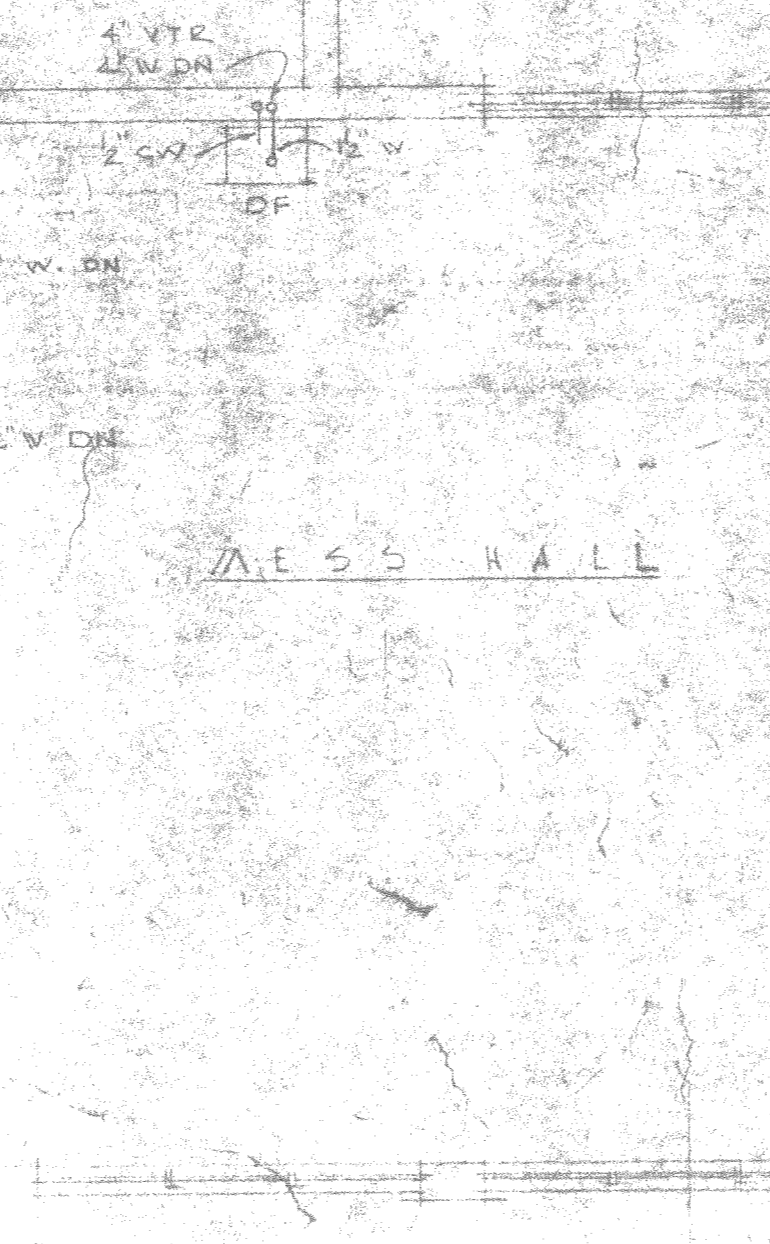


UNDERFLOOR PLAN  
SCULLERY NO. 2  
1/8" = 1'-0"

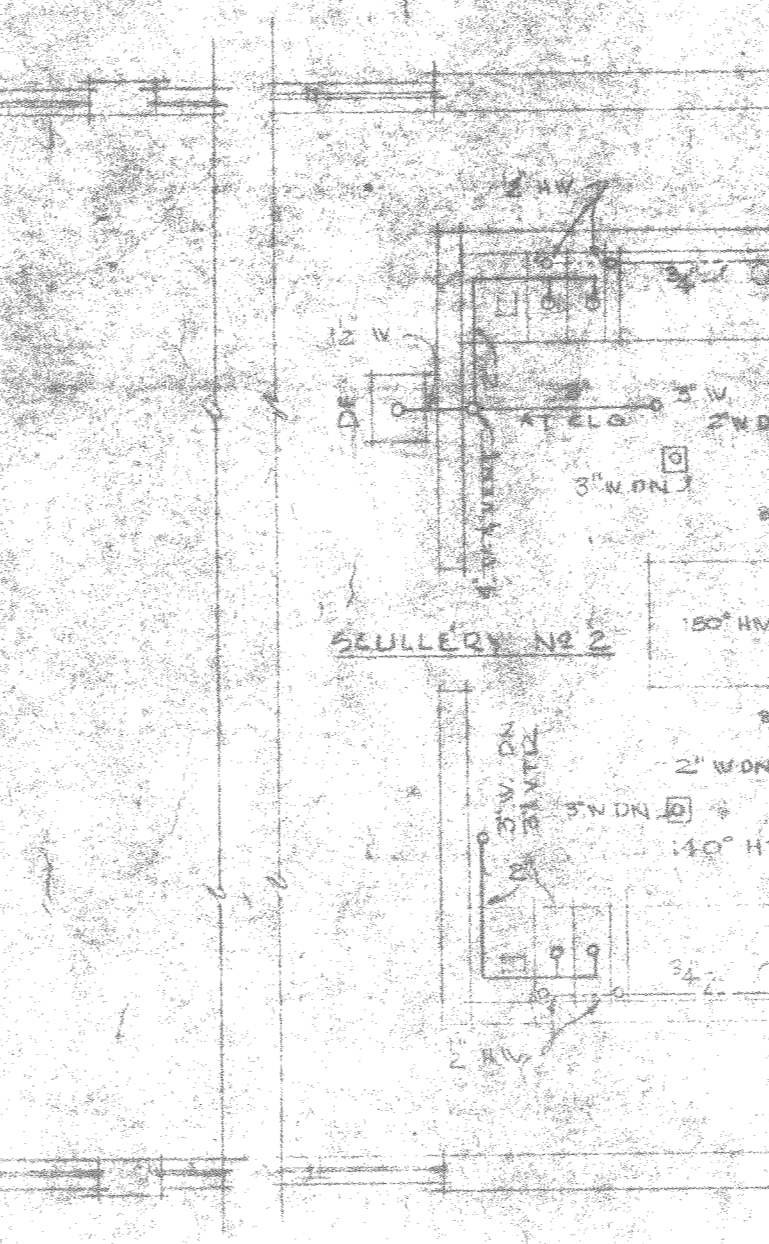

UNDERFLOOR PLAN  
SCULLERY NO. 2  
1/8" = 1'-0"

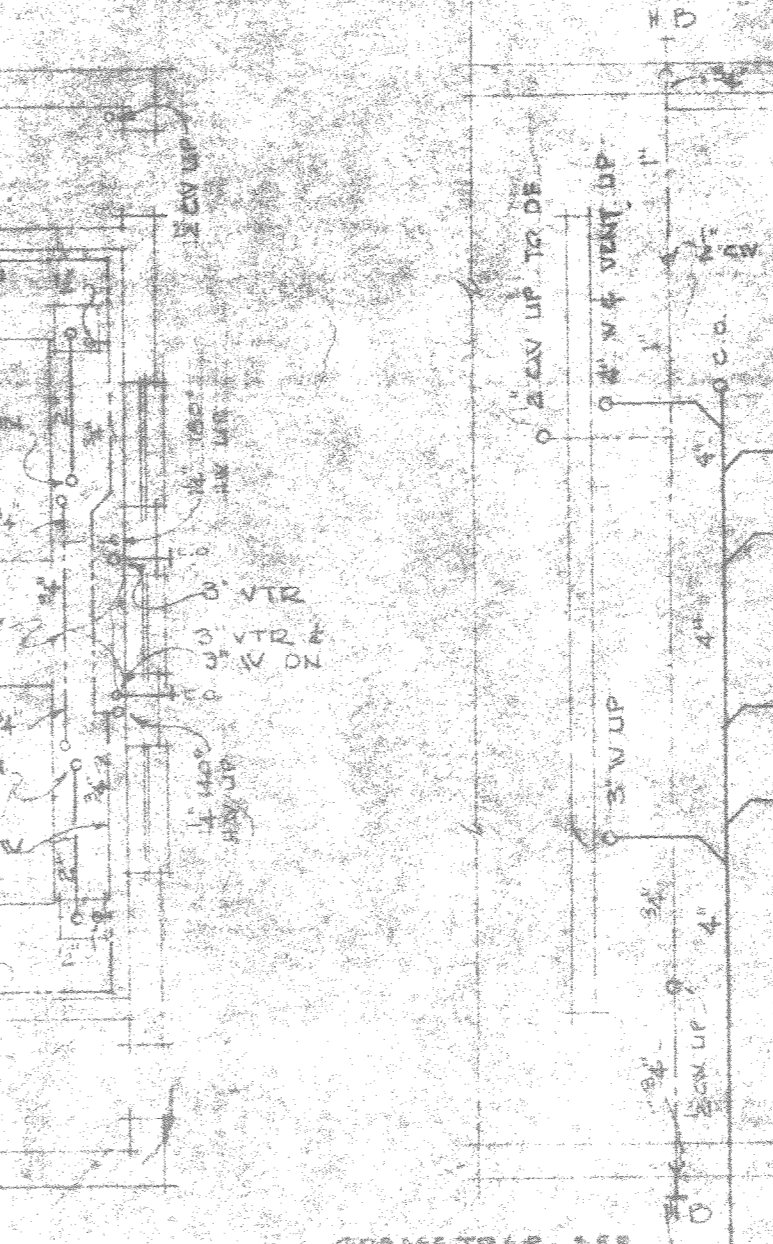

UNDERFLOOR PLAN  
SCULLERY NO. 2  
1/8" = 1'-0"

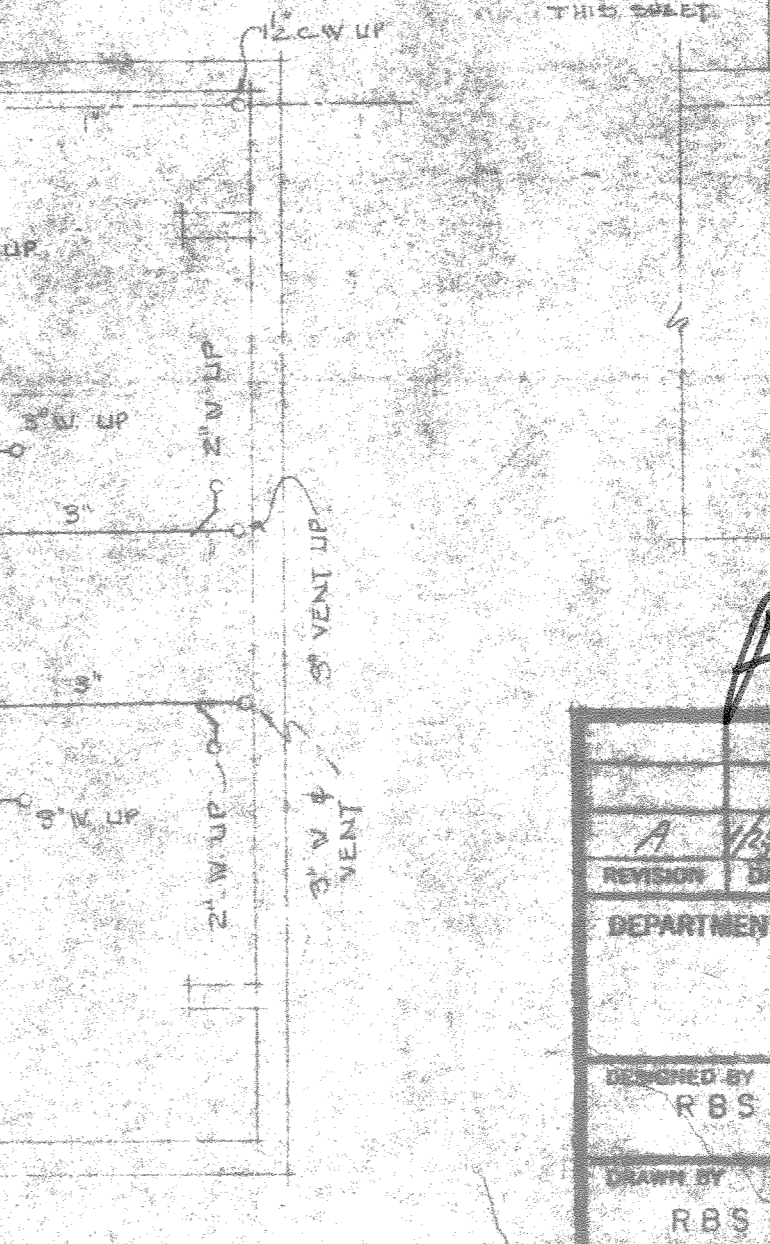

UNDERFLOOR PLAN  
SCULLERY NO. 2  
1/8" = 1'-0"



UNDERFLOOR PLAN - REAR WING  
1/8" = 1'-0"

AS-226

A WORK NOT REUSED AS BUILT

DEPARTMENT OF THE ARMY BUREAU OF YARDS & DOCKS  
DISTRICT PUBLIC WORKS OFFICE, 6TH FLOOR, CHARLESTON, S.C.  
SIX ASSOCIATES INC. - ARCHITECTS & ENGINEERS  
ASHEVILLE, N.C.

DESIGNED BY R.B.S.  
DRAWN BY R.B.S.  
CHECKED BY J.K.W.  
SUBMITTED BY

MARINE CORPS AIR FACILITY  
PETERFIELD POINT, CAMP LEJEUNE, NORTH CAROLINA  
EM SUBSISTENCE BUILDING  
PLUMBING

APPROVED: [Signature] DATE: 5/27/53  
SCALE AS NOTED SPEC 5276-2  
SHEET 24 OF 58 NOV 7, 1953  
Y & D DRAWING NO. 5053

FLOOR PLAN

GRAPHIC SCALE

