



DATE	DESCRIPTION	BY	APPROVED

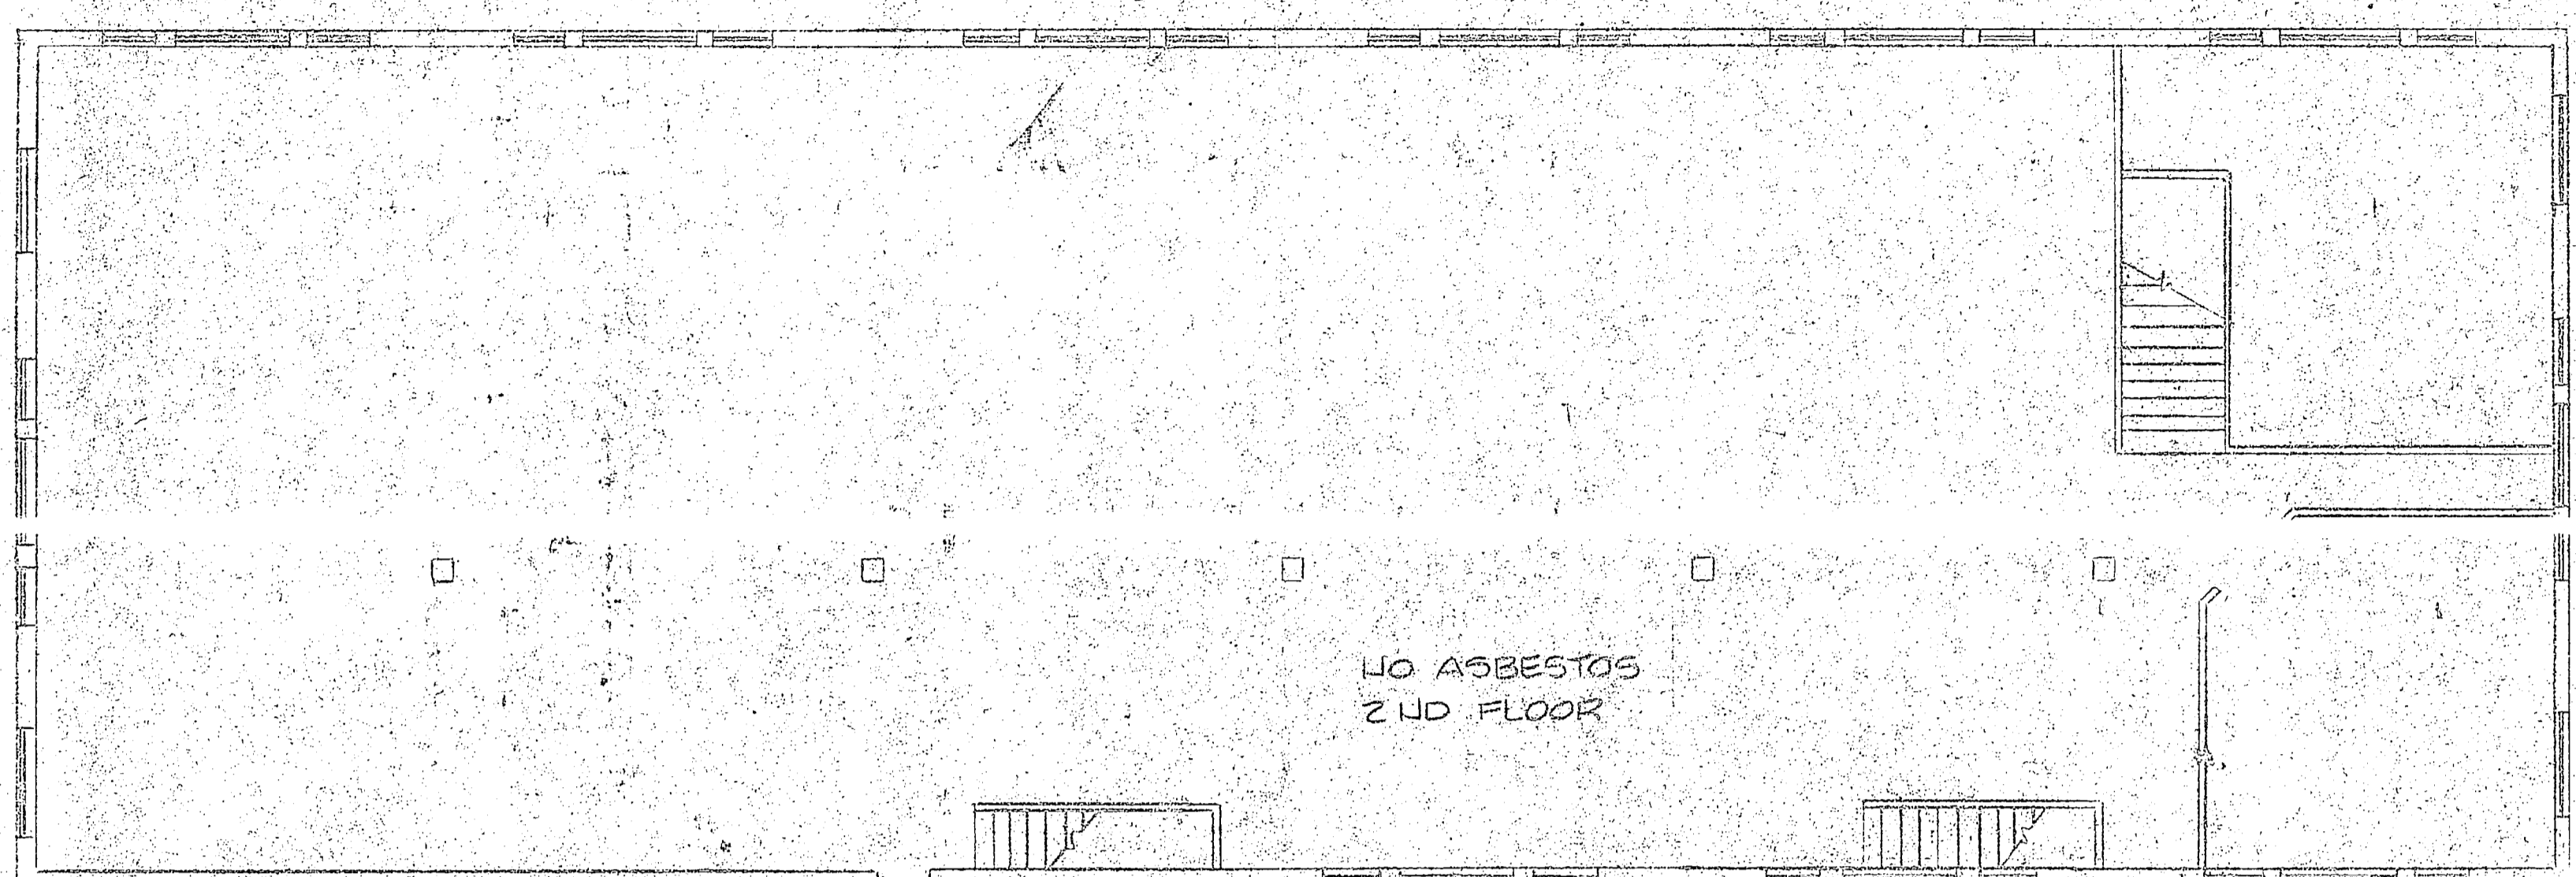

SECOND FLOOR PLAN



FIRST FLOOR PLAN - BLDG. 20
1/8" = 1'-0"

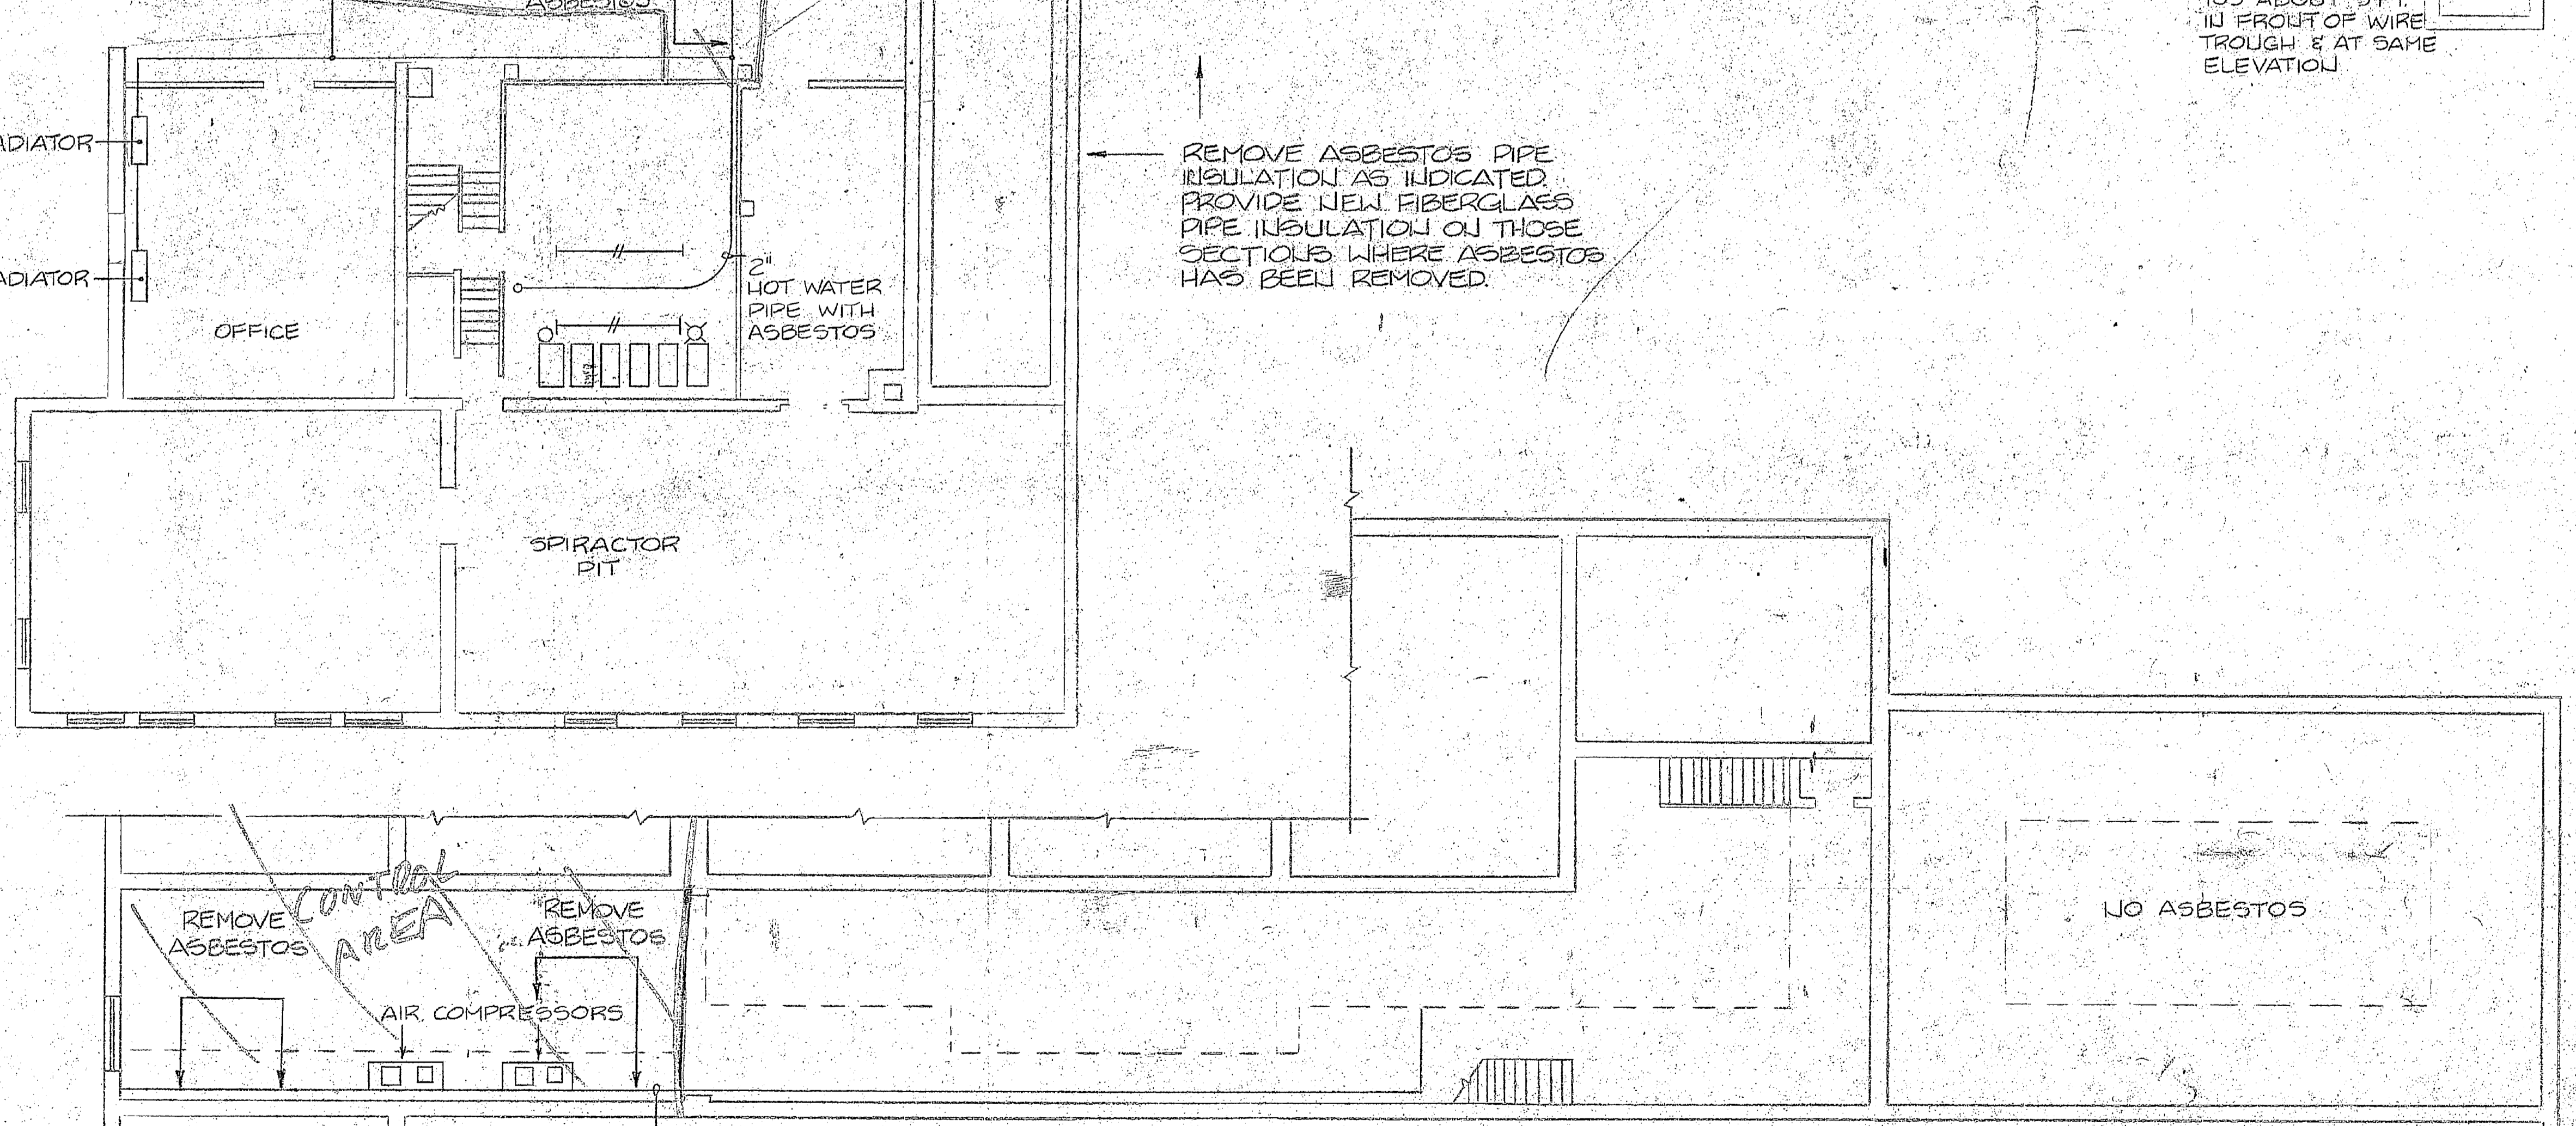



PIPE GALLERY AND PUMP ROOM PLAN
1/8" = 1'-0"

CONTROL AREA

CONTROL AREA

CONTROL AREA

- NOTES:
- REMOVE ASBESTOS PIPE INSULATION ON THIS AREA OF PIPING ONLY.
 - REPLACE ASBESTOS WITH FIBERGLASS PIPE INSULATION WITH ALL SERVICE JACKET.

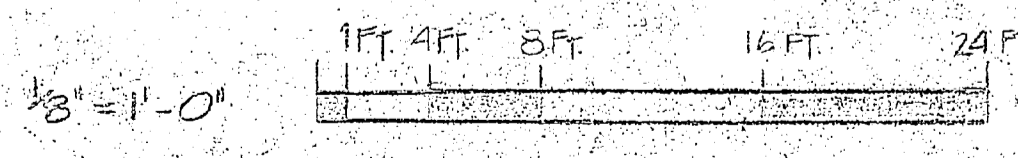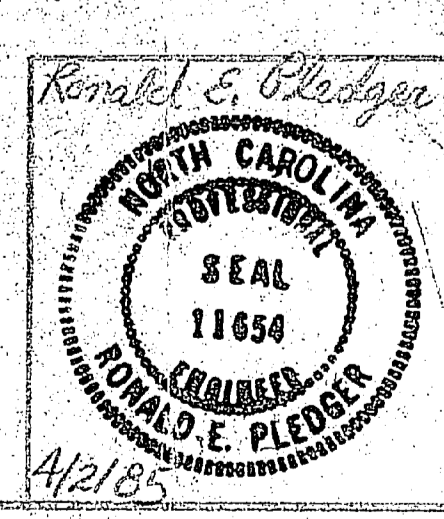

DIBBLE & ASSOCIATES, P.A. P.O. BOX 1881 WASHINGTON, N.C. 27689		DEPARTMENT OF THE NAVY NAVAL FACILITIES ENGINEERING CONTRACTS MARINE CORPS BASE SANJO LEASING, BEaufORT, CAROLINA	
DES. RSP P.L. JWH ENR. RSP CHECKED BY: [Signature] DESIGNED BY: [Signature]	SIZE 3 CORE ASBEST. ENG.	CLASSIFICATION NO. 4126492	AR-1
APPROVED: [Signature] DATE SUPERVISOR: [Signature] DATE	SCALE: GRAPHIC SPEC: 05-84-7419	SHEET 27 OF 28	

JR. JOHNSON